



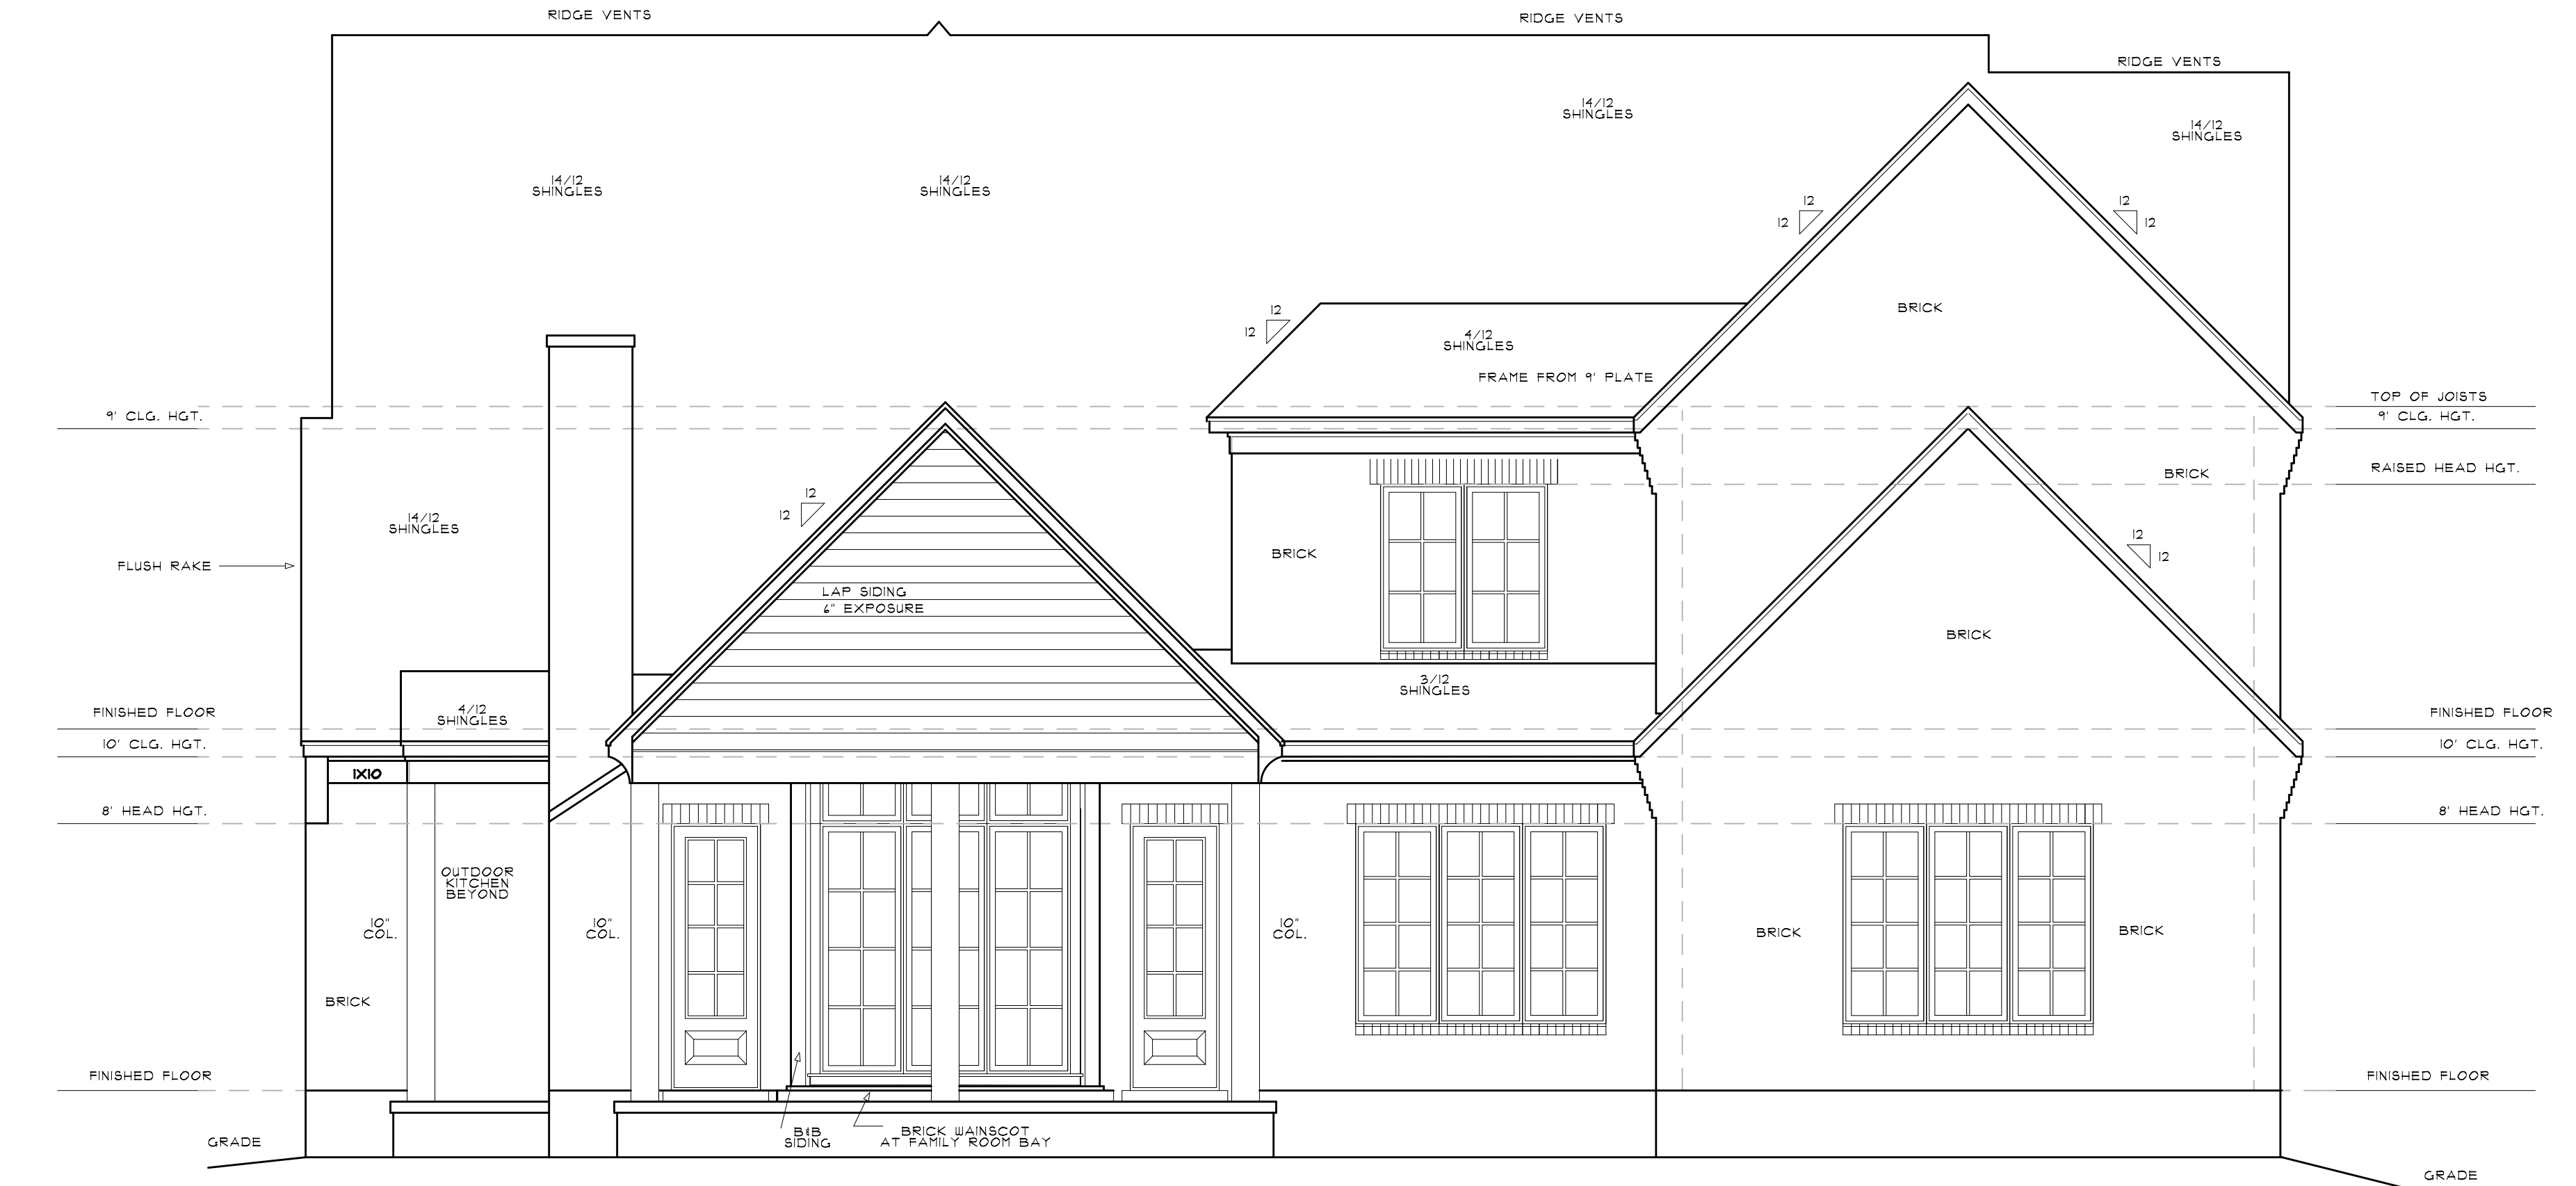


REAR ELEVATION

1/4\"=1'-0"

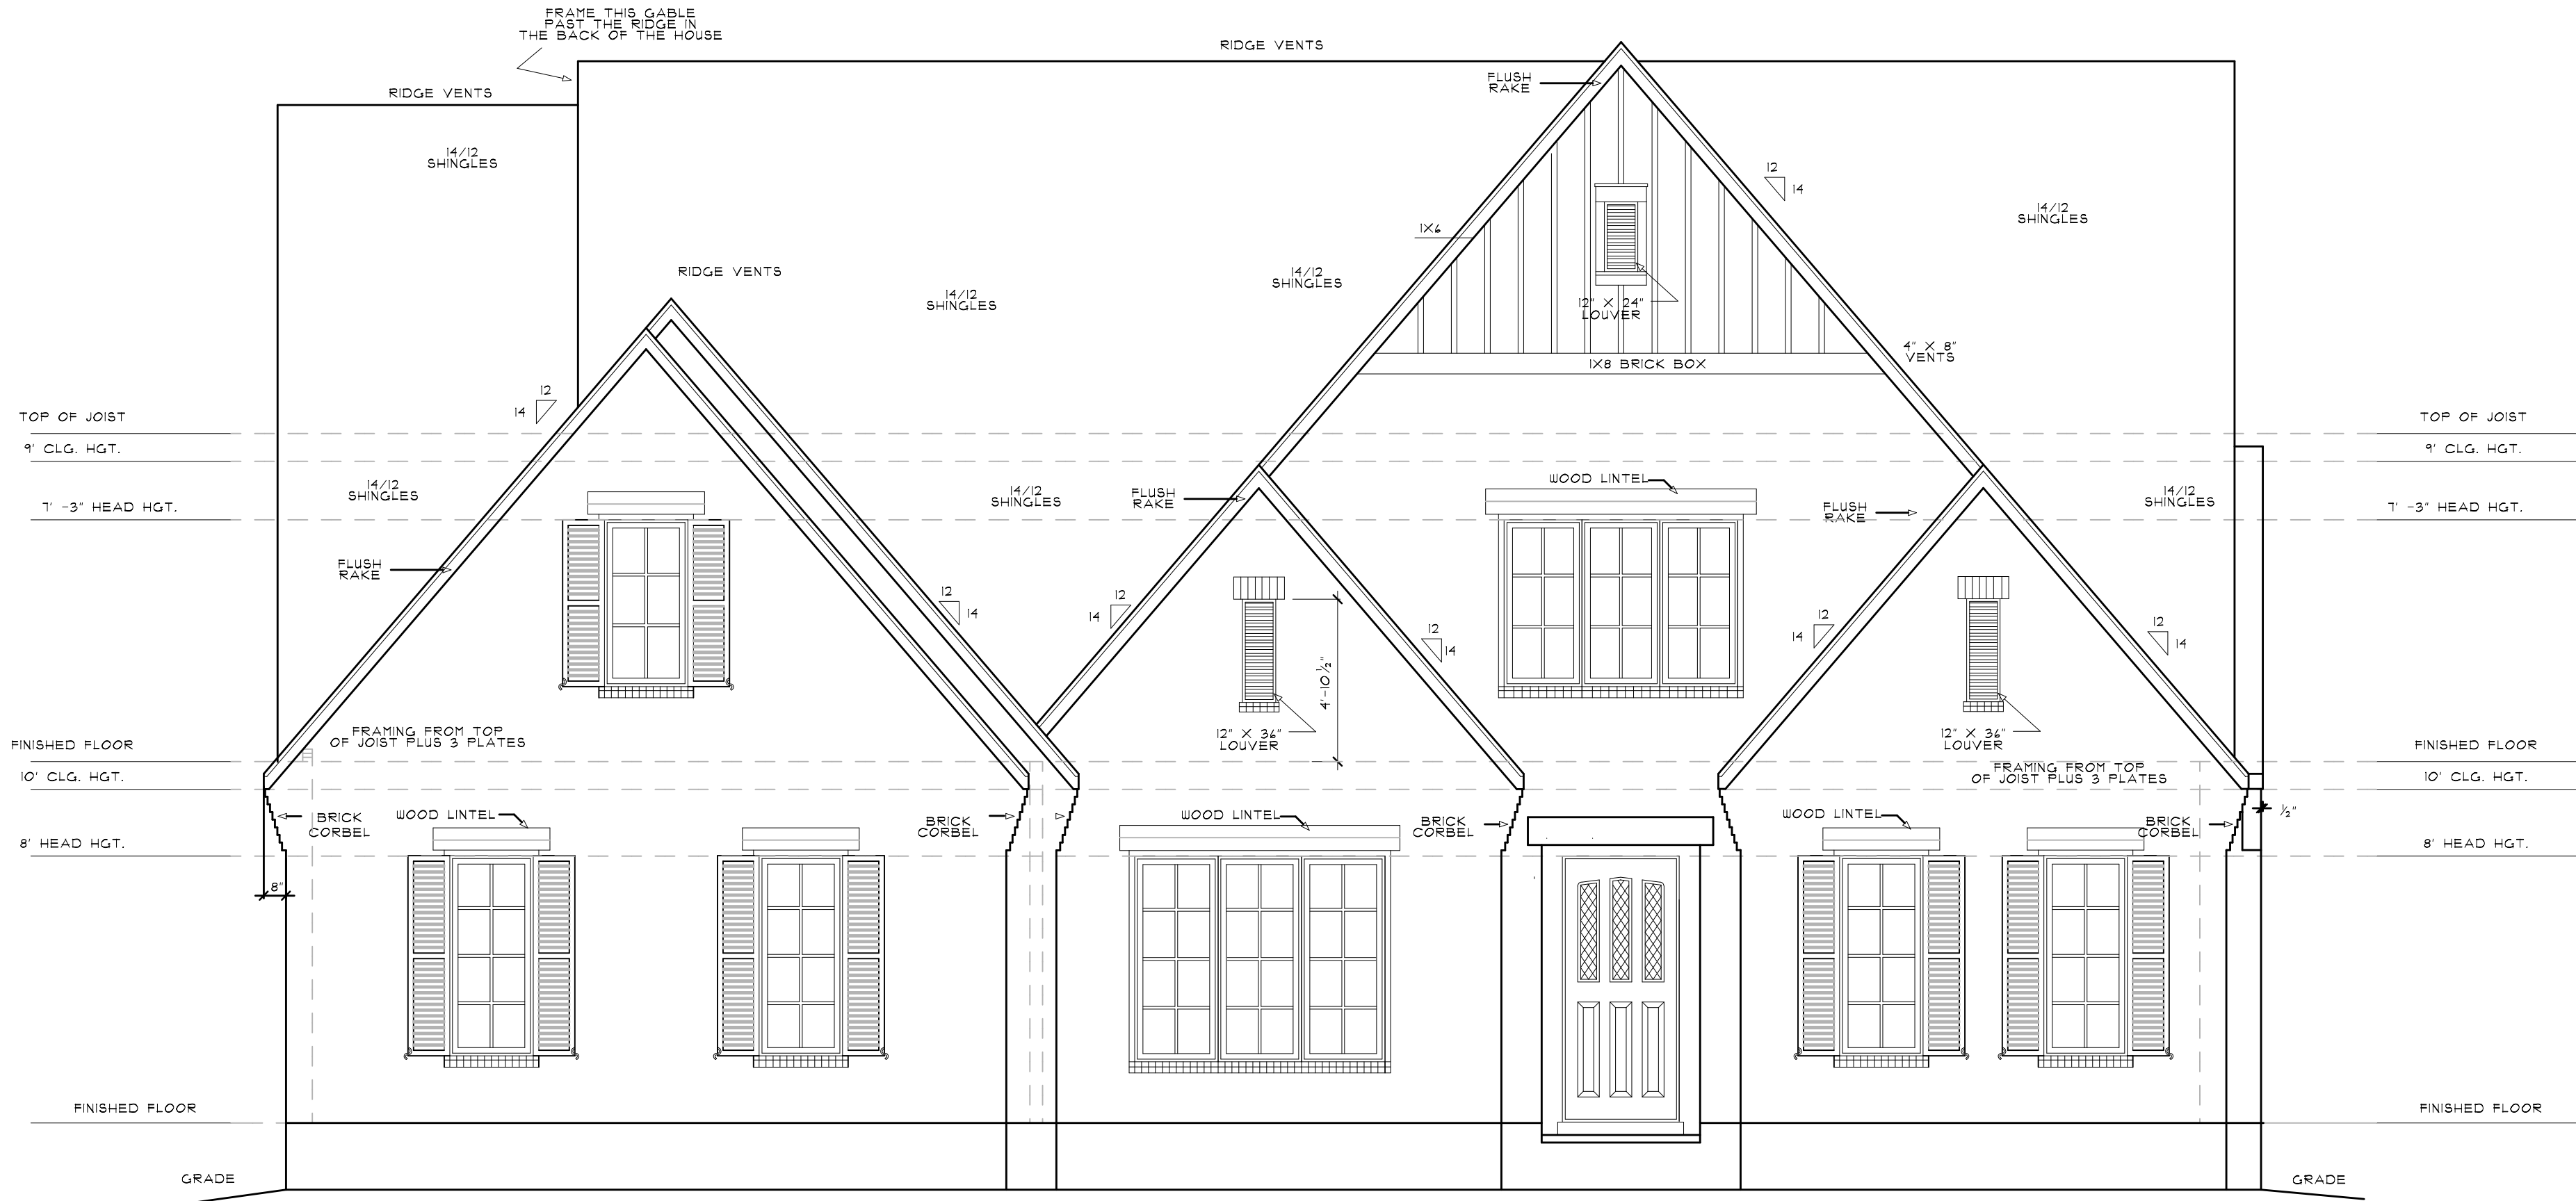


FRONT ELEVATION

1/4\"=1'-0"

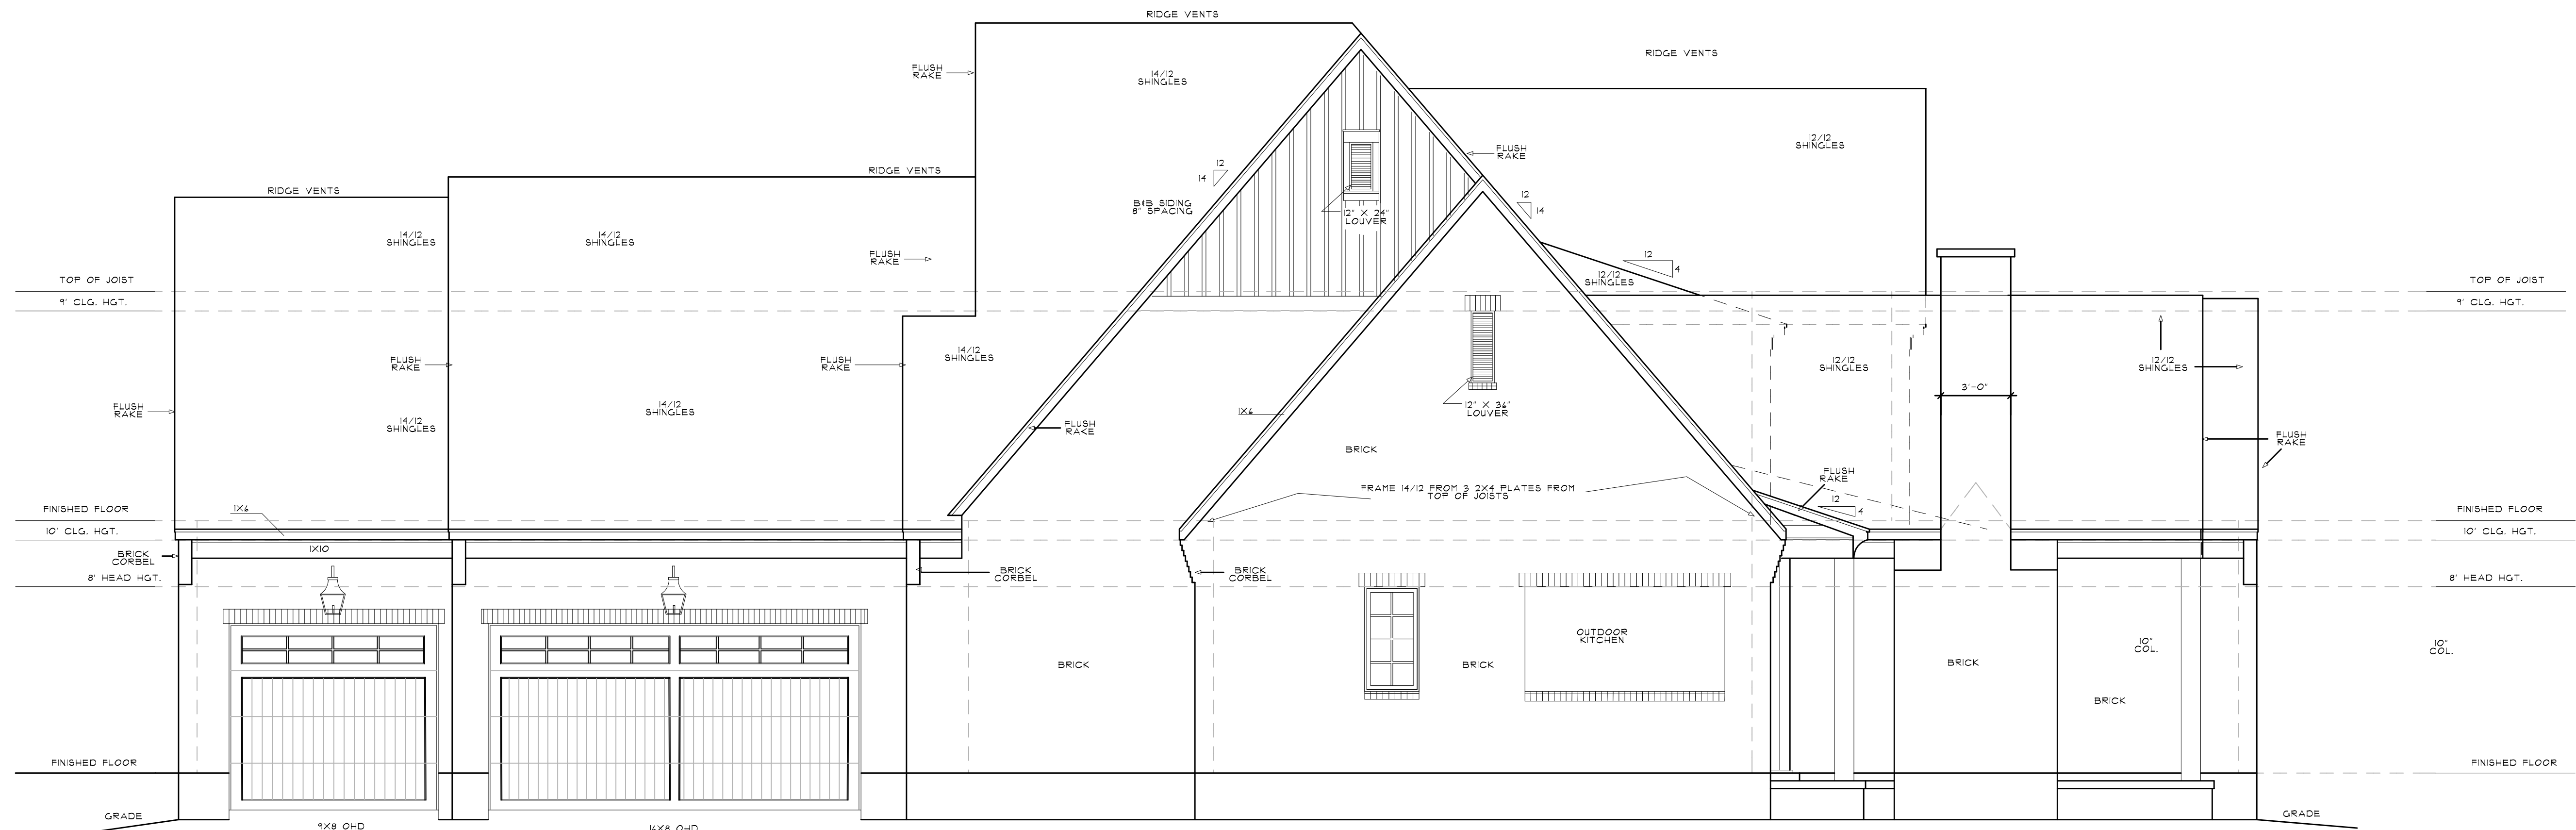


RIGHT ELEVATION

1/4"=1'-0"

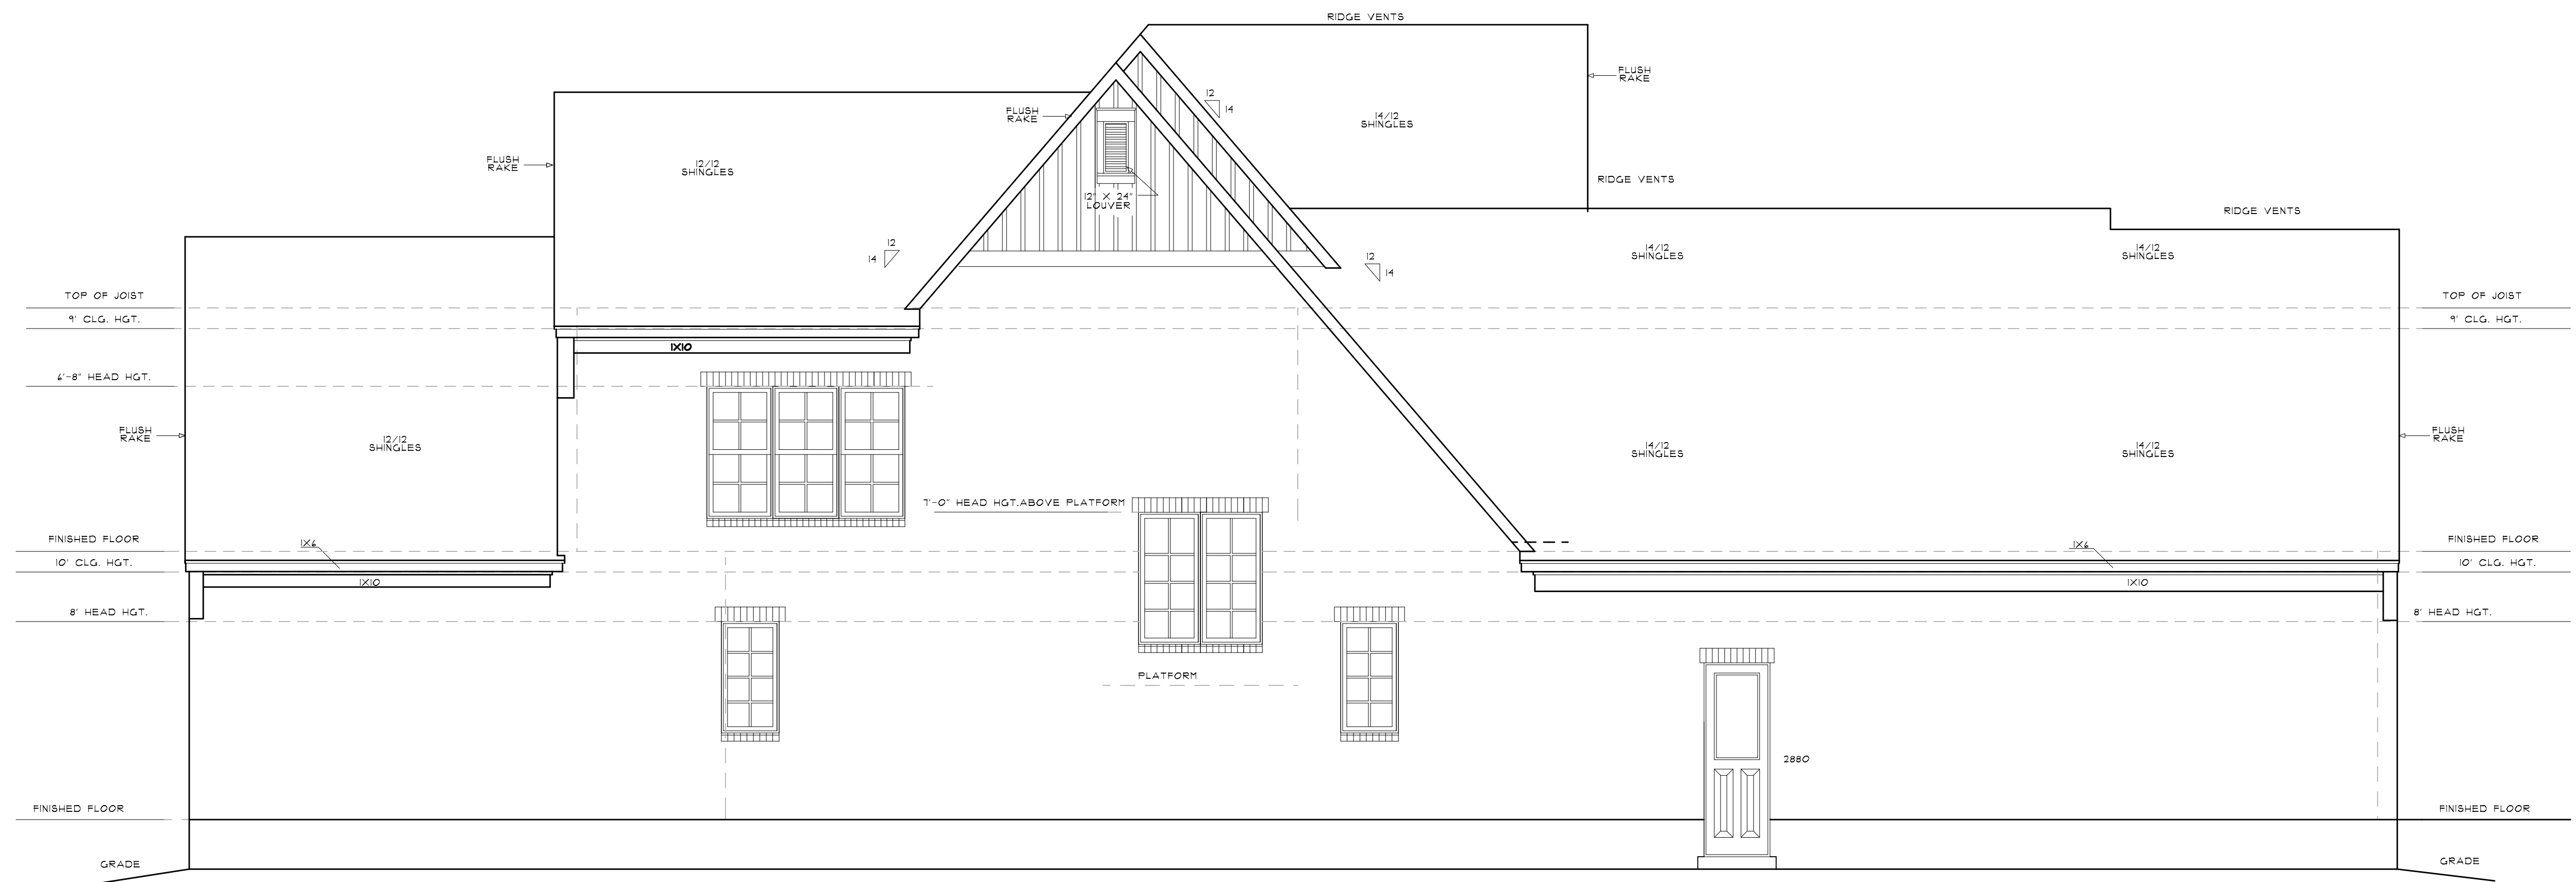

LEFT ELEVATION

1/4"=1'-0"

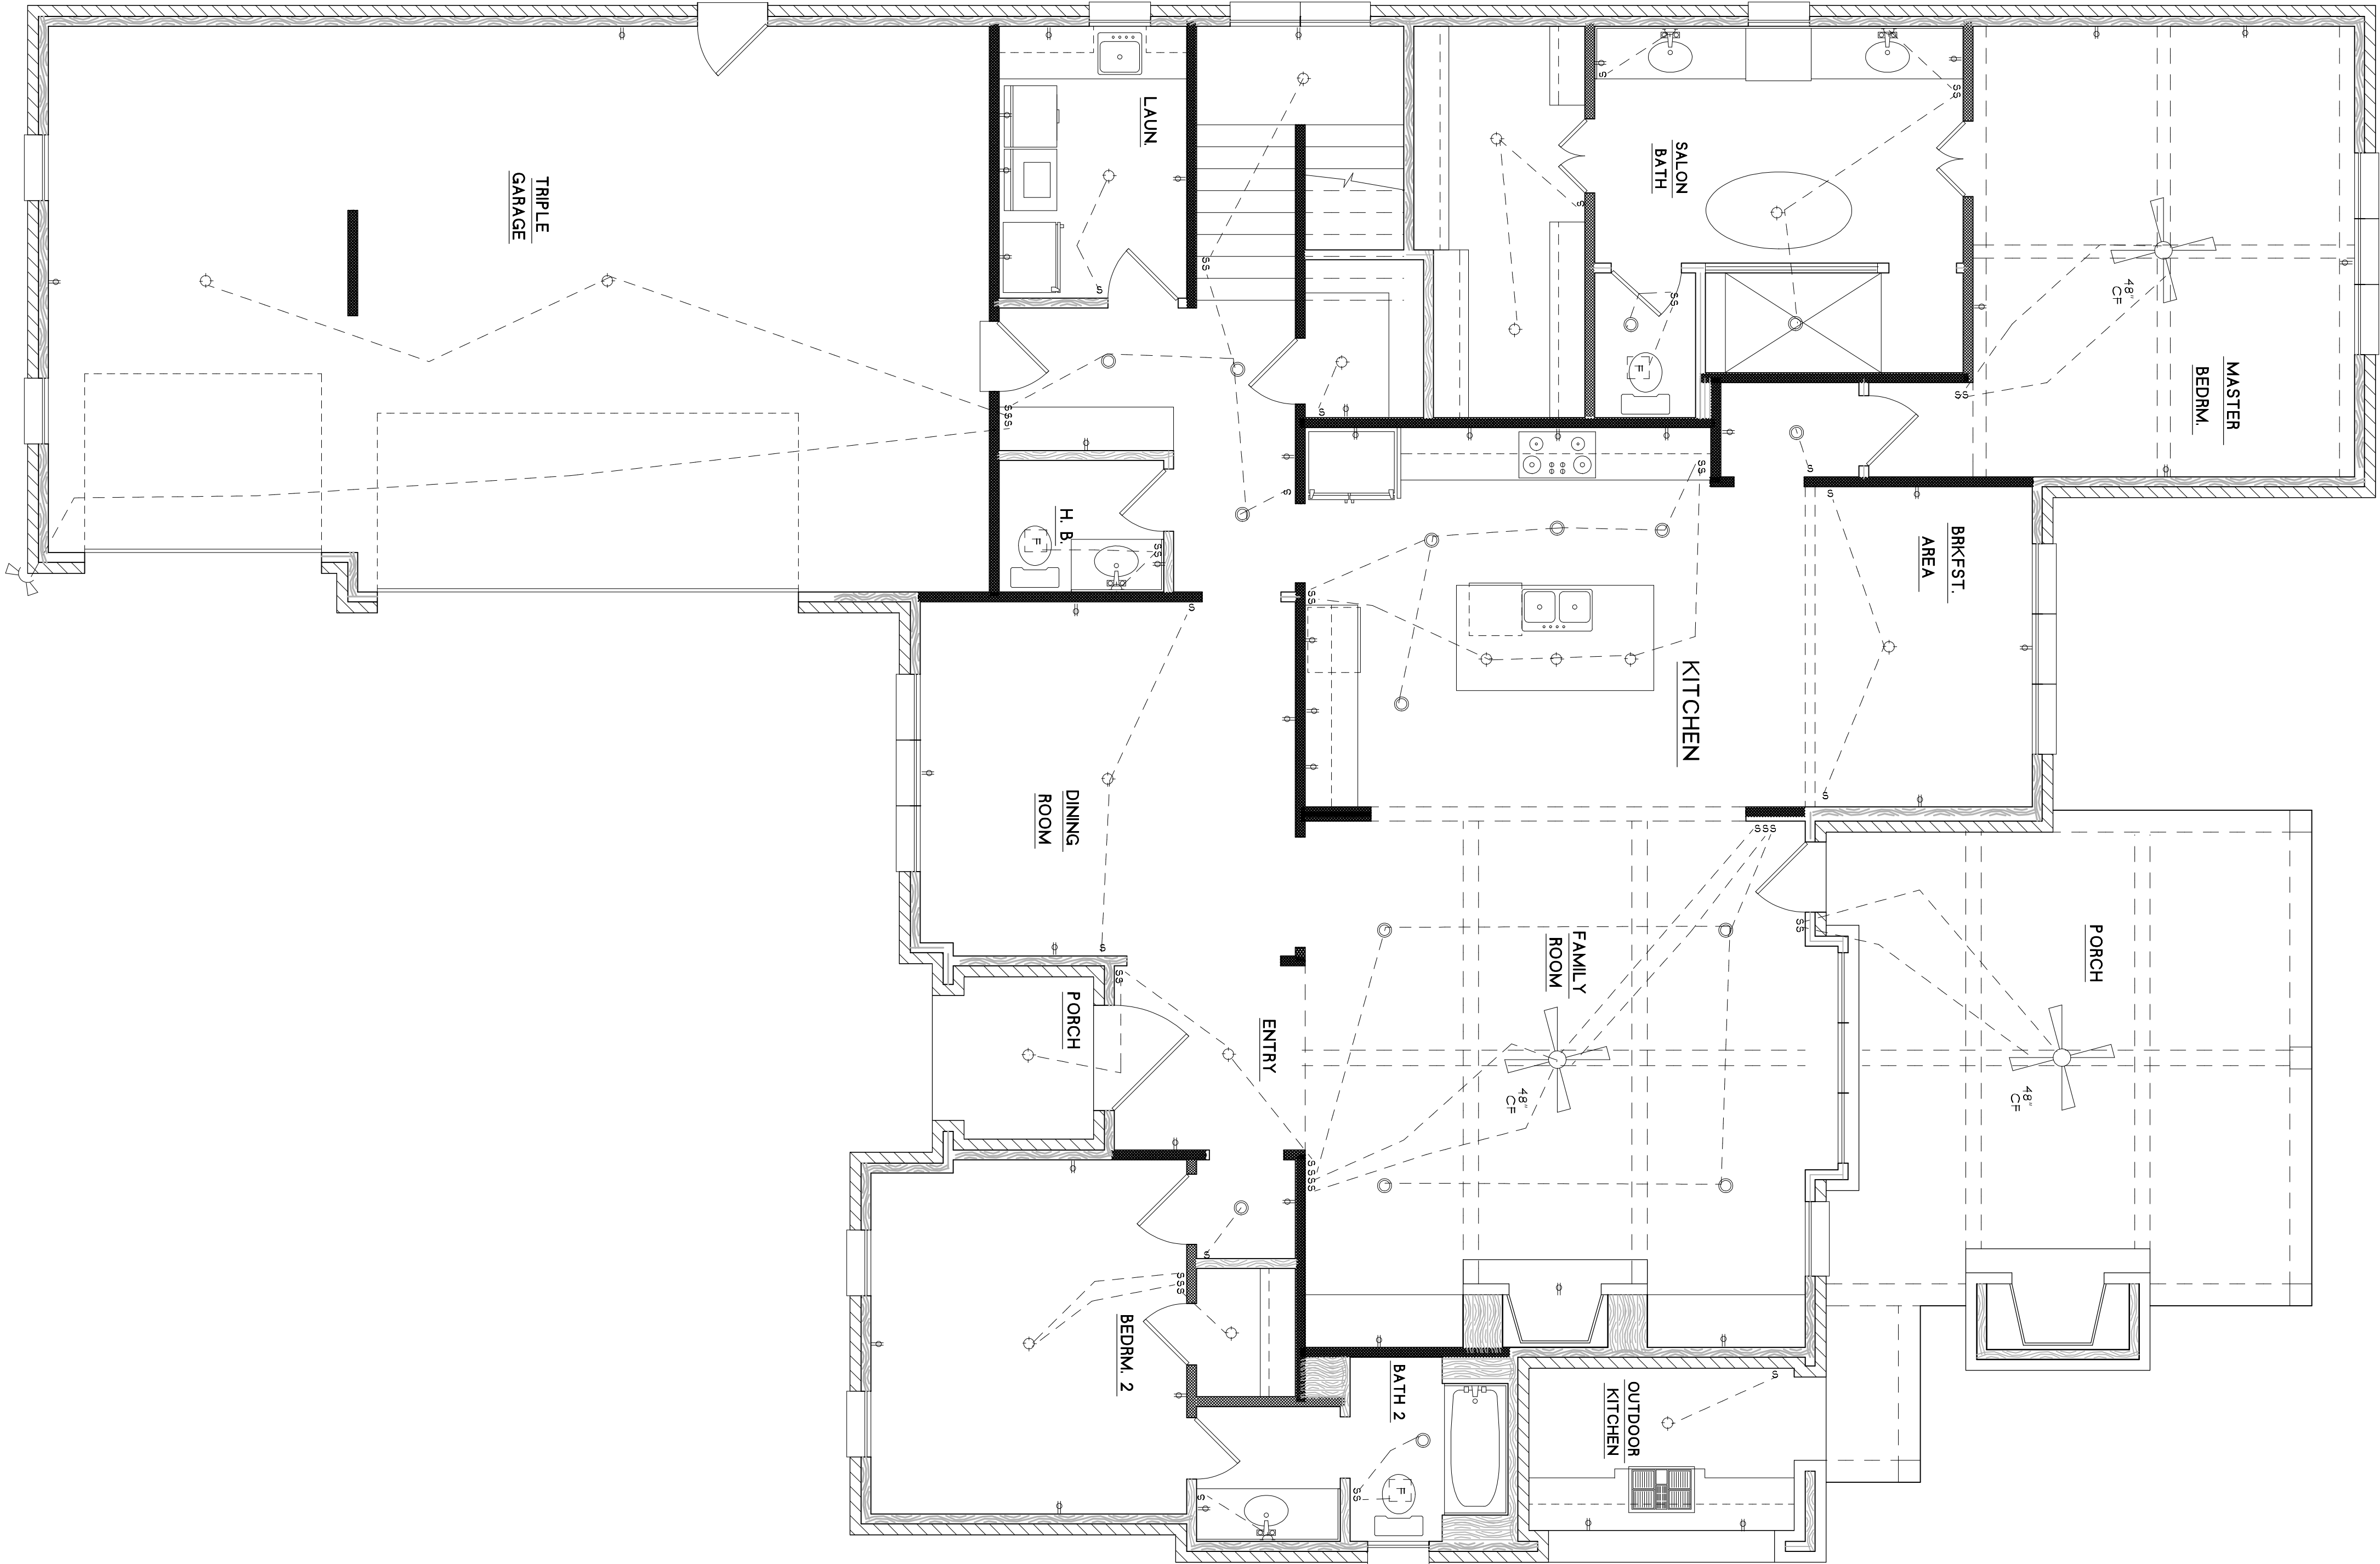

FIRST FLOOR ELECTRICAL PLAN

1/4"=1'-0"

AREAS:	
HTD DN	2312 SQ. FT.
HTD UP	1050 SQ. FT.
TOTAL HTD.	3362 SQ. FT.
PORCH	505 SQ. FT.
CAR & STOR.	162 SQ. FT.

CHECKED :

DRAWN :

DATE : 10-22-2020


SCALE : AS NOTED

JOB NO. : B524

SHEET


3

AMERICAN INSTITUTE
OF BUILDING DESIGN
®

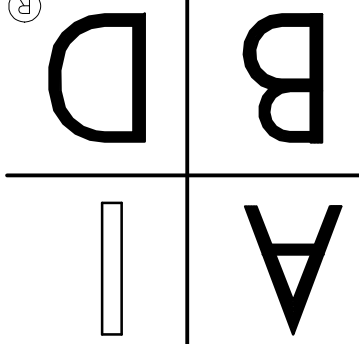


CLASSIC HOME DESIGNS.

ED YENDREK AND ASSOCIATES
1133 POLO DRIVE, SUITE 105
COLLIERVILLE, TENNESSEE 38017
PHONE: 901-854-6900 FAX: 901-854-7170
WWW.CHDHOME.COM

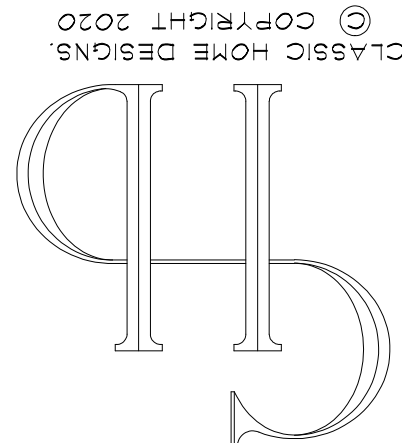

© CLASSIC HOME DESIGNS
COPYRIGHT 2020

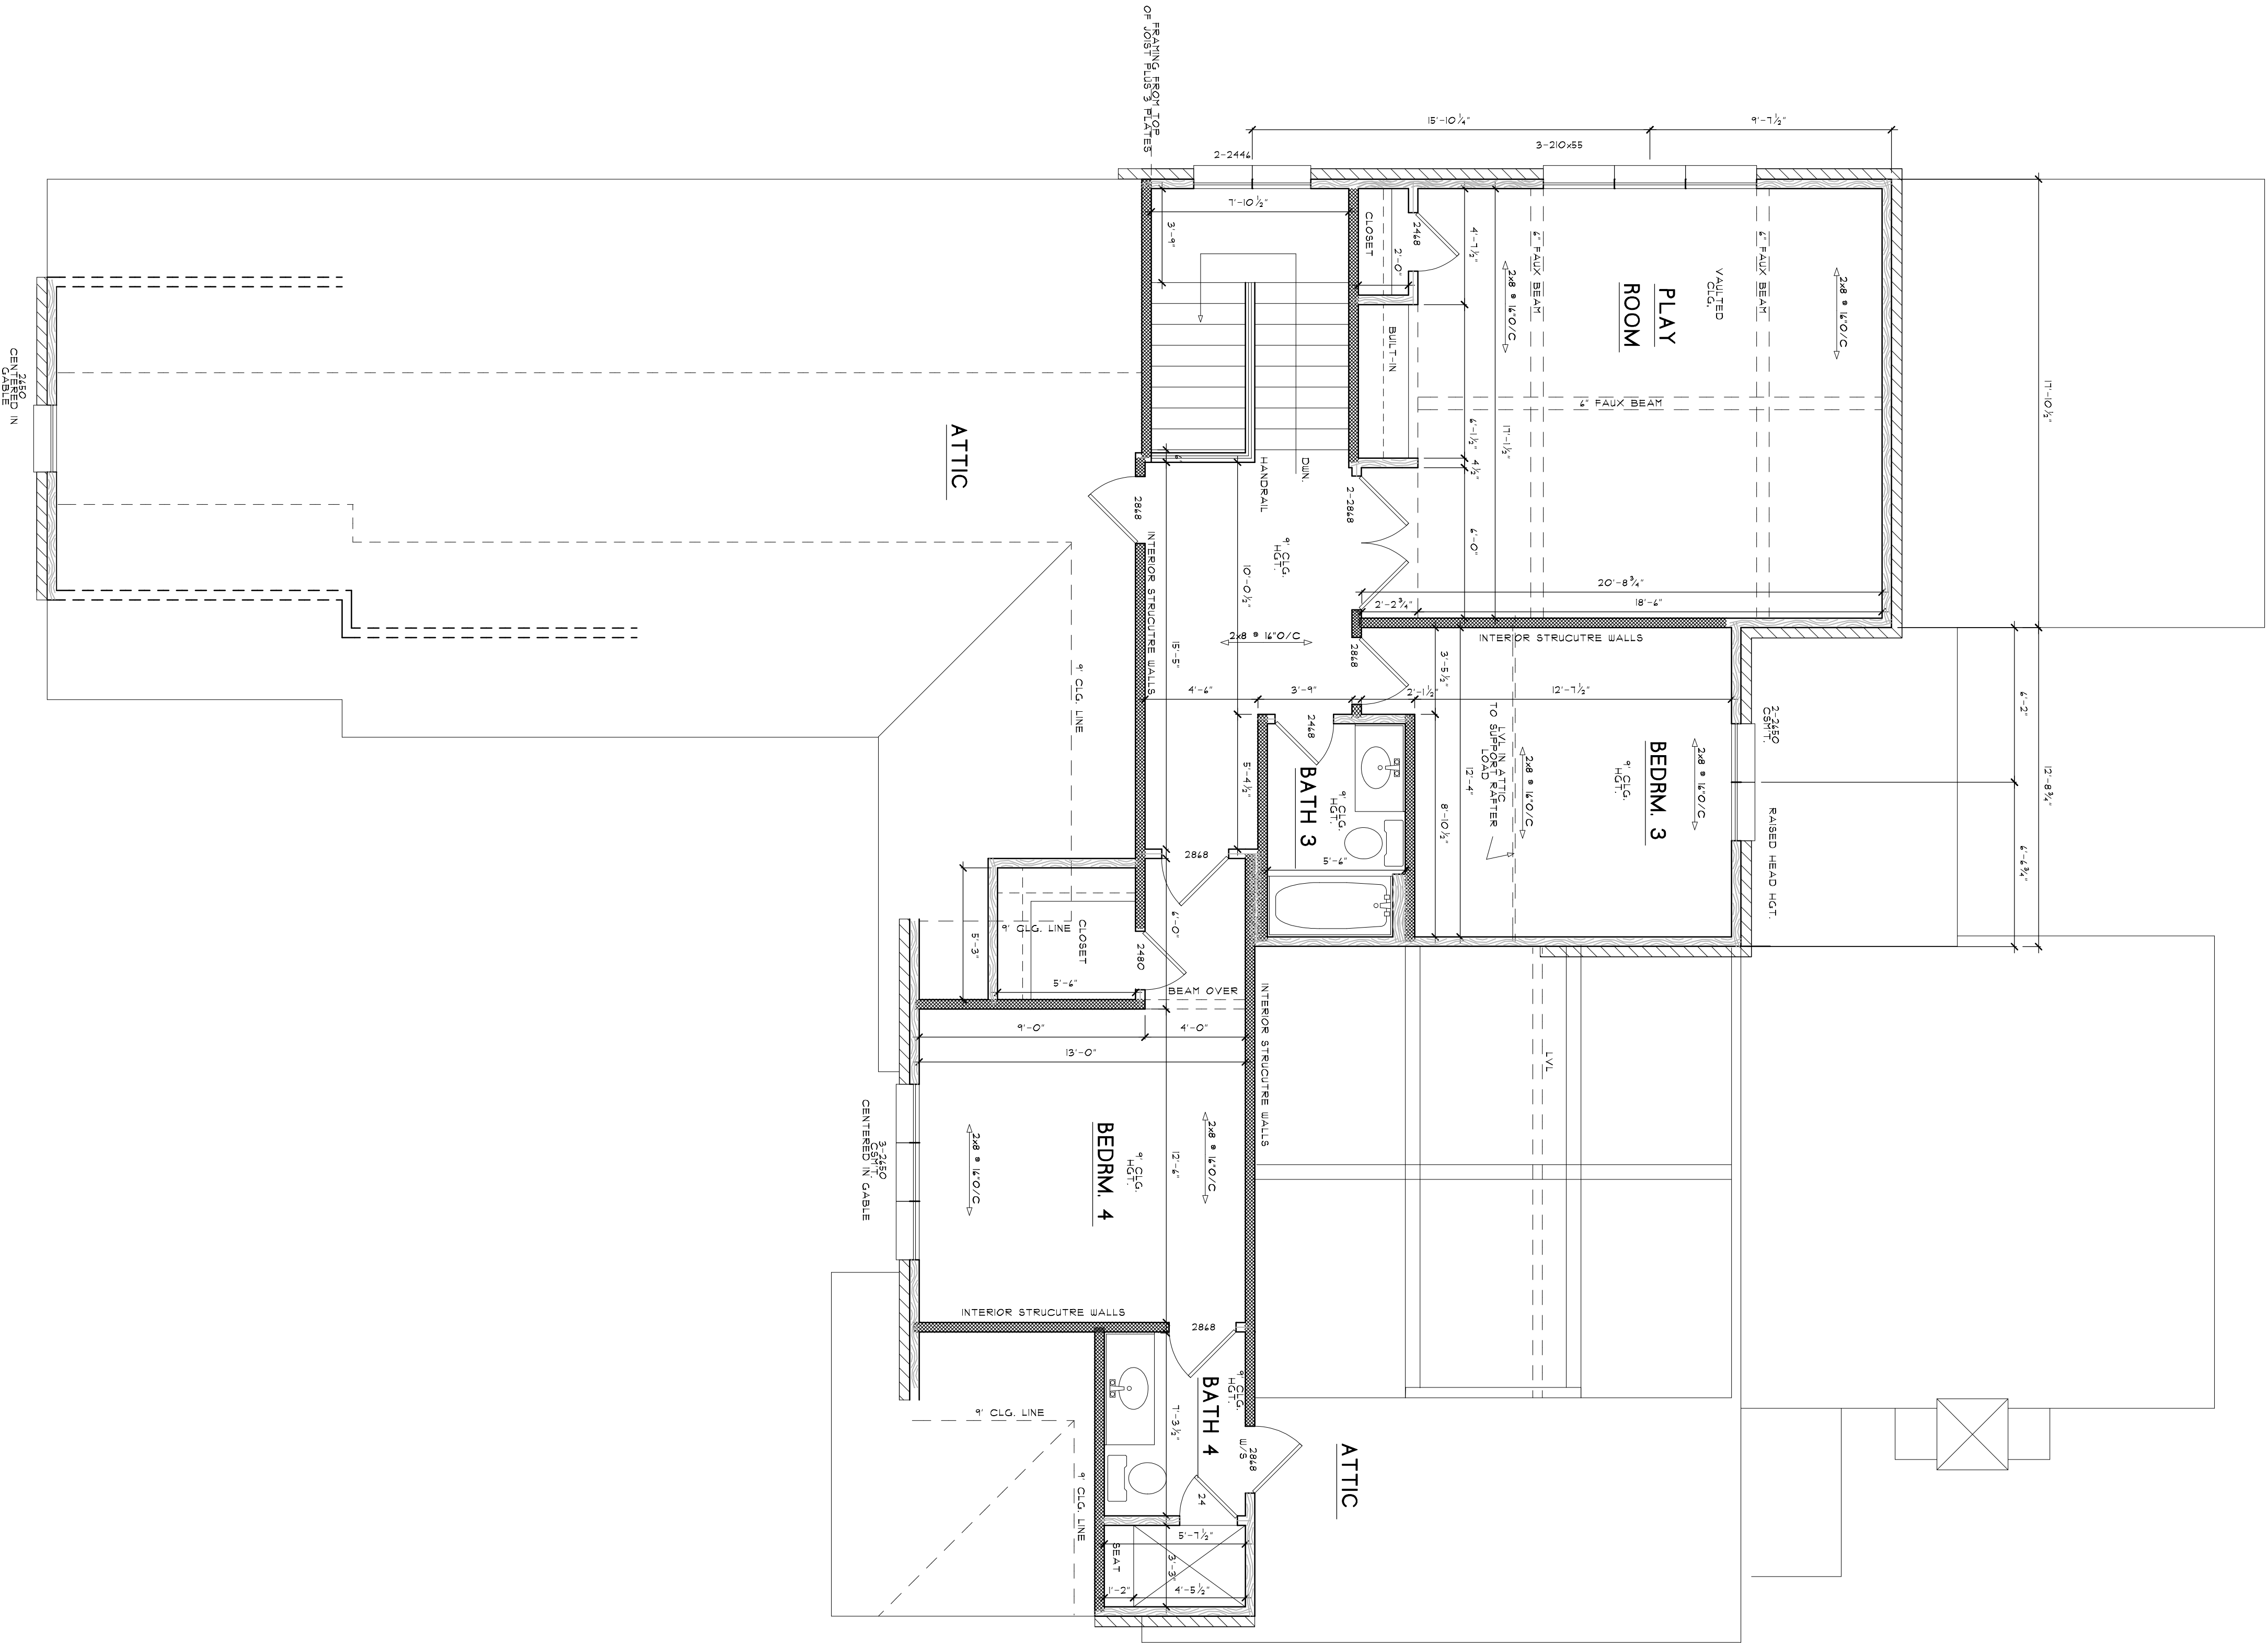

SECOND FLOOR PLAN

1/4\"/>

AREAS:	
HTD DN	2312 SQ. FT.
HTD UP	1050 SQ. FT.
TOTAL HTD.	3362 SQ. FT.
PORCH	505 SQ. FT.
CAR & STOR.	162 SQ. FT.

AMERICAN INSTITUTE OF BUILDING DESIGN®

B

A


CLASSIC HOME DESIGNS.

ED YENDREK AND ASSOCIATES
1133 POLO DRIVE, SUITE 105
COLLIERVILLE, TENNESSEE 38017
PHONE: 901-854-6900 FAX: 901-854-7170
WWW.CHDHOME.COM

CLASSIC HOME DESIGNS
© COPYRIGHT 2020

CHD

DRAWN :	CHECKED :
DATE : 10-22-2020	SCALE : AS NOTED
JOB NO. : B524	SHEET

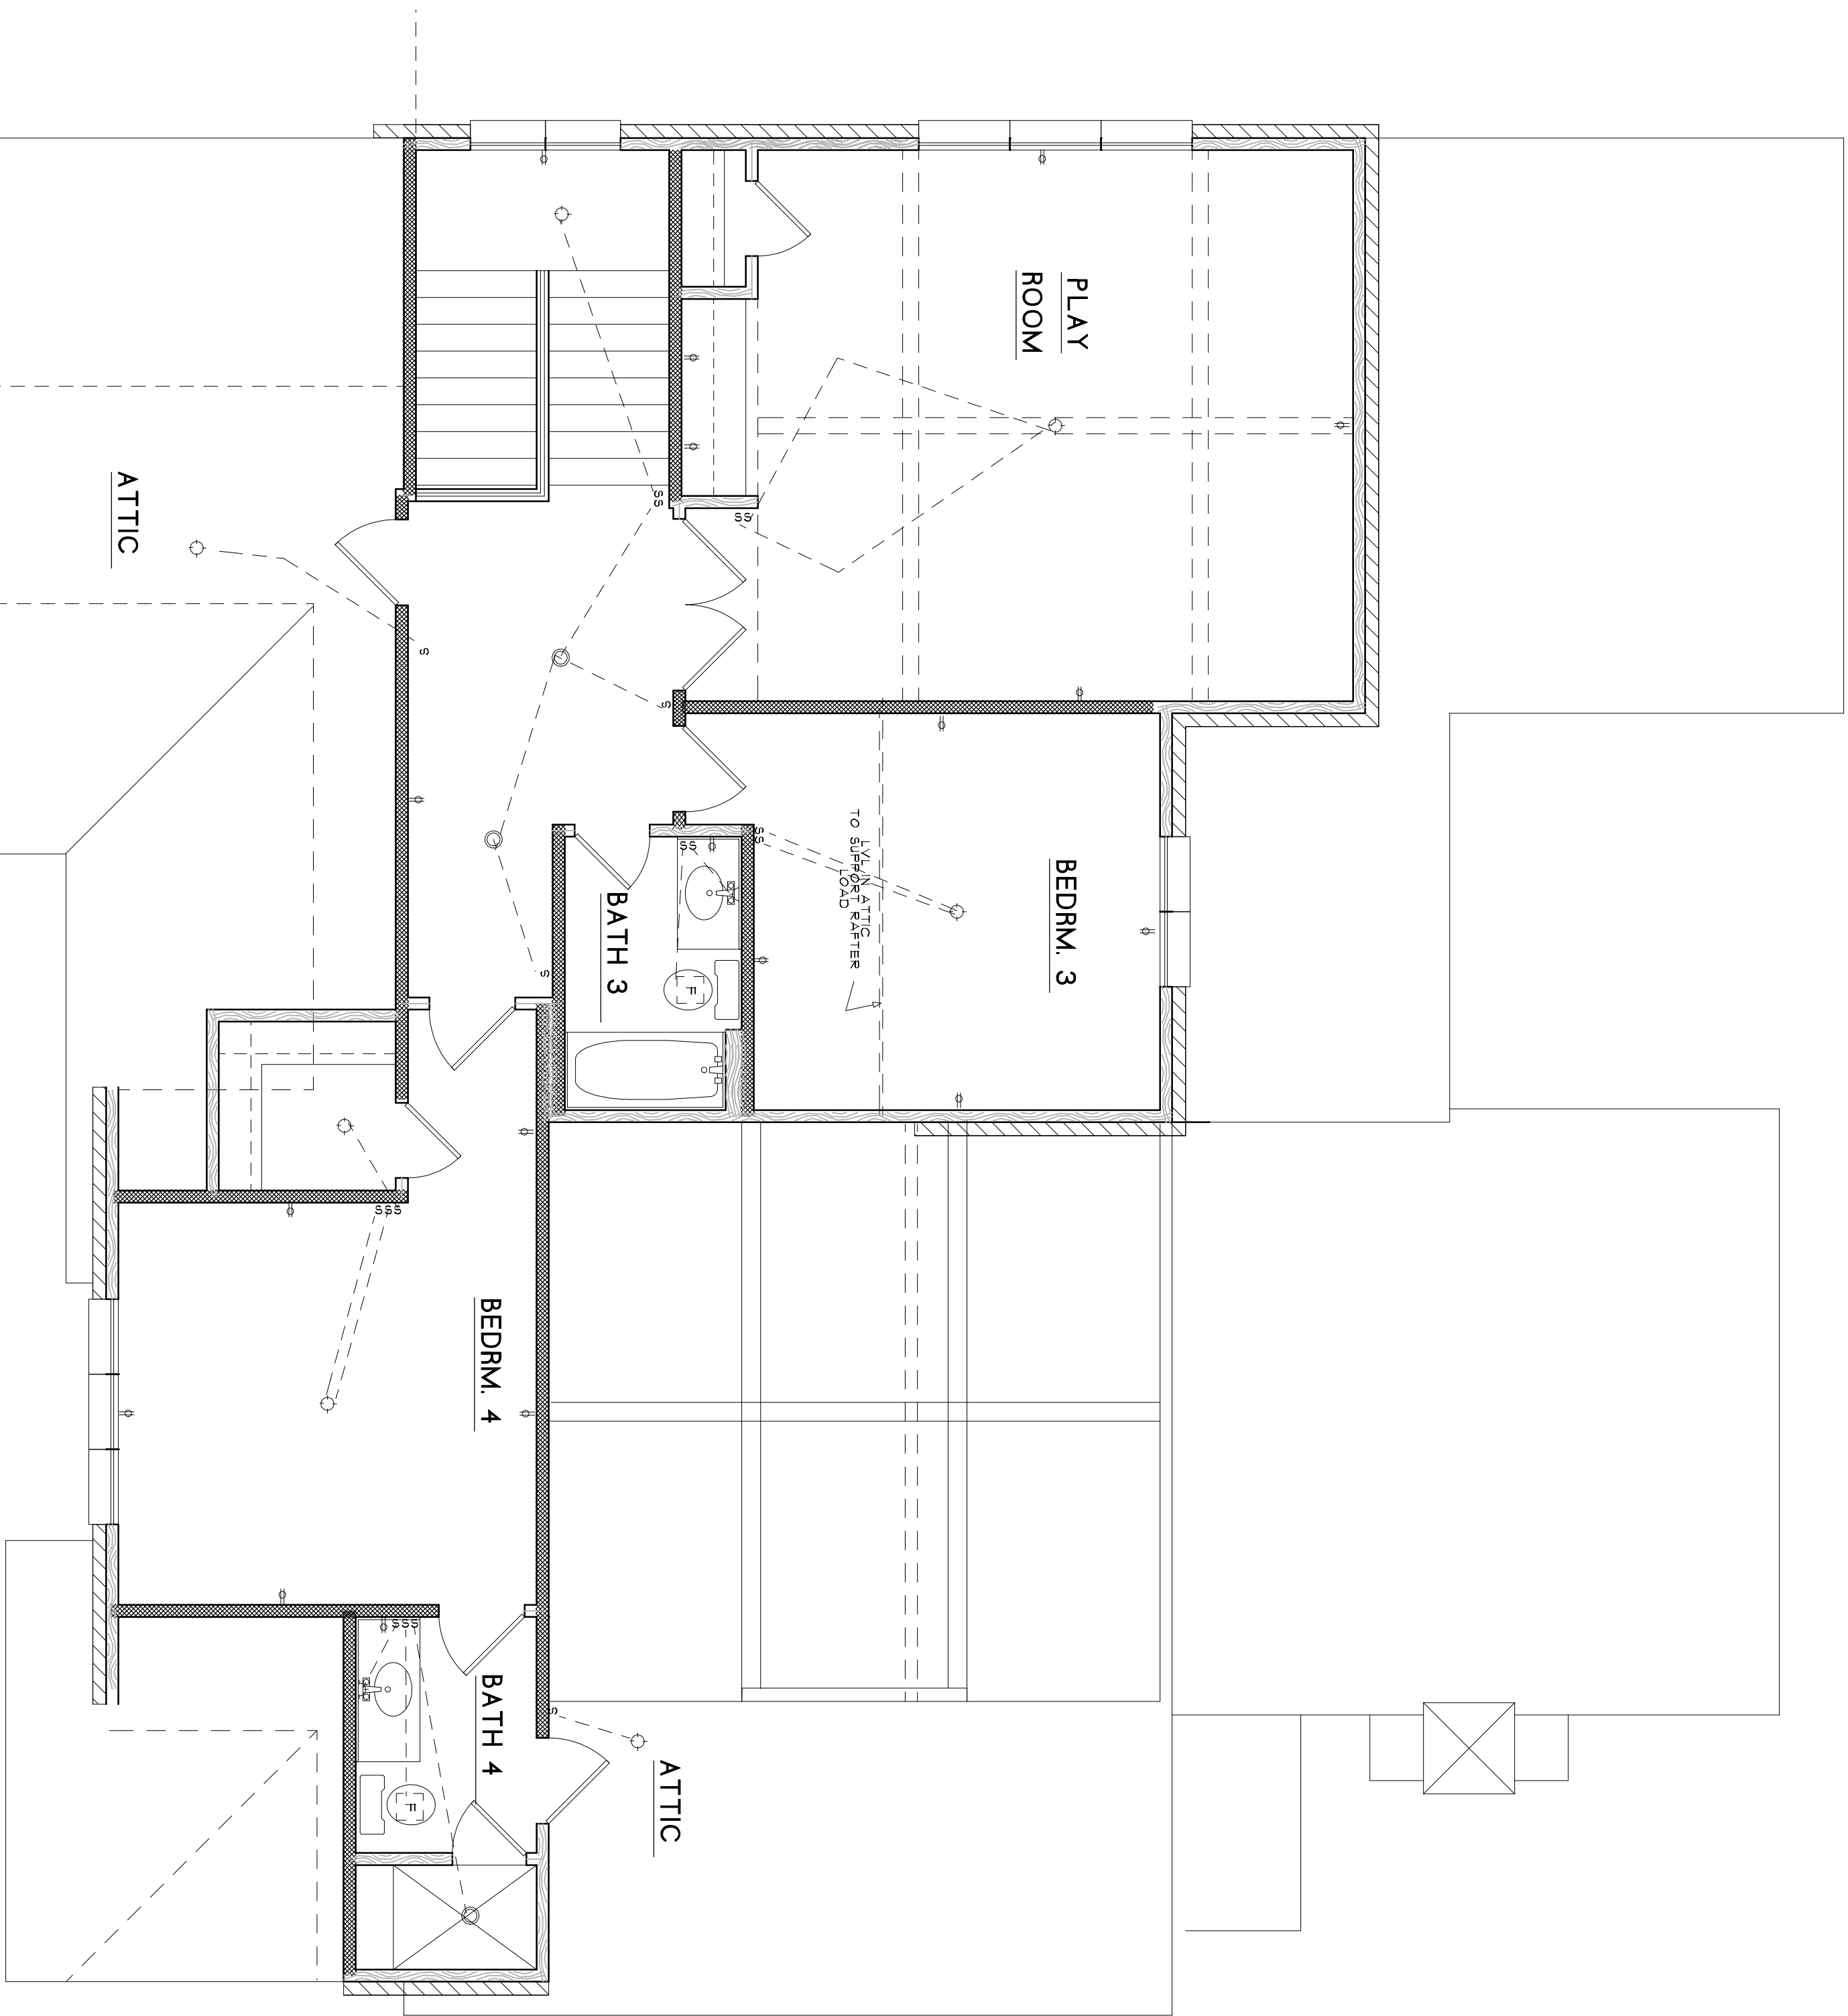

SECOND FLOOR ELECTRICAL PLAN

1/4"=1'-0"

AREAS:	
HTD DN	2312 SQ. FT.
HTD UP	1050 SQ. FT.
TOTAL HTD.	3362 SQ. FT.
PORCH	505 SQ. FT.
GAR & STOR.	162 SQ. FT.

DATE : 10-22-2020


SCALE : AS NOTED

JOB NO. : B524

SHEET

01


AMERICAN INSTITUTE
OF BUILDING DESIGN

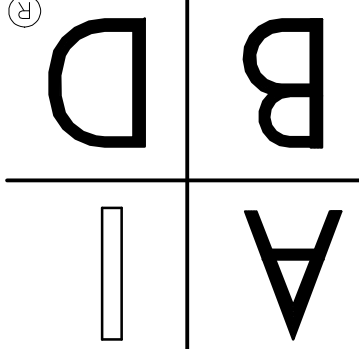


CLASSIC HOME DESIGNS.

ED YENDREK AND ASSOCIATES
1133 POLO DRIVE, SUITE 105
COLLIERVILLE, TENNESSEE 38017
PHONE: 901-854-6900 FAX: 901-854-7170
WWW.CHDHOME.COM

© COPYRIGHT 2020

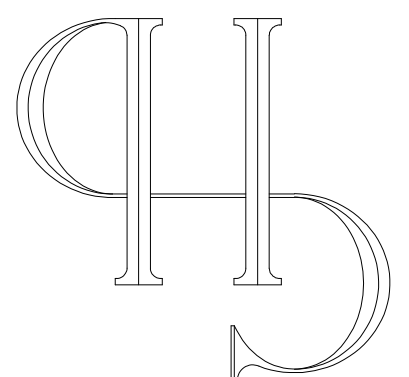

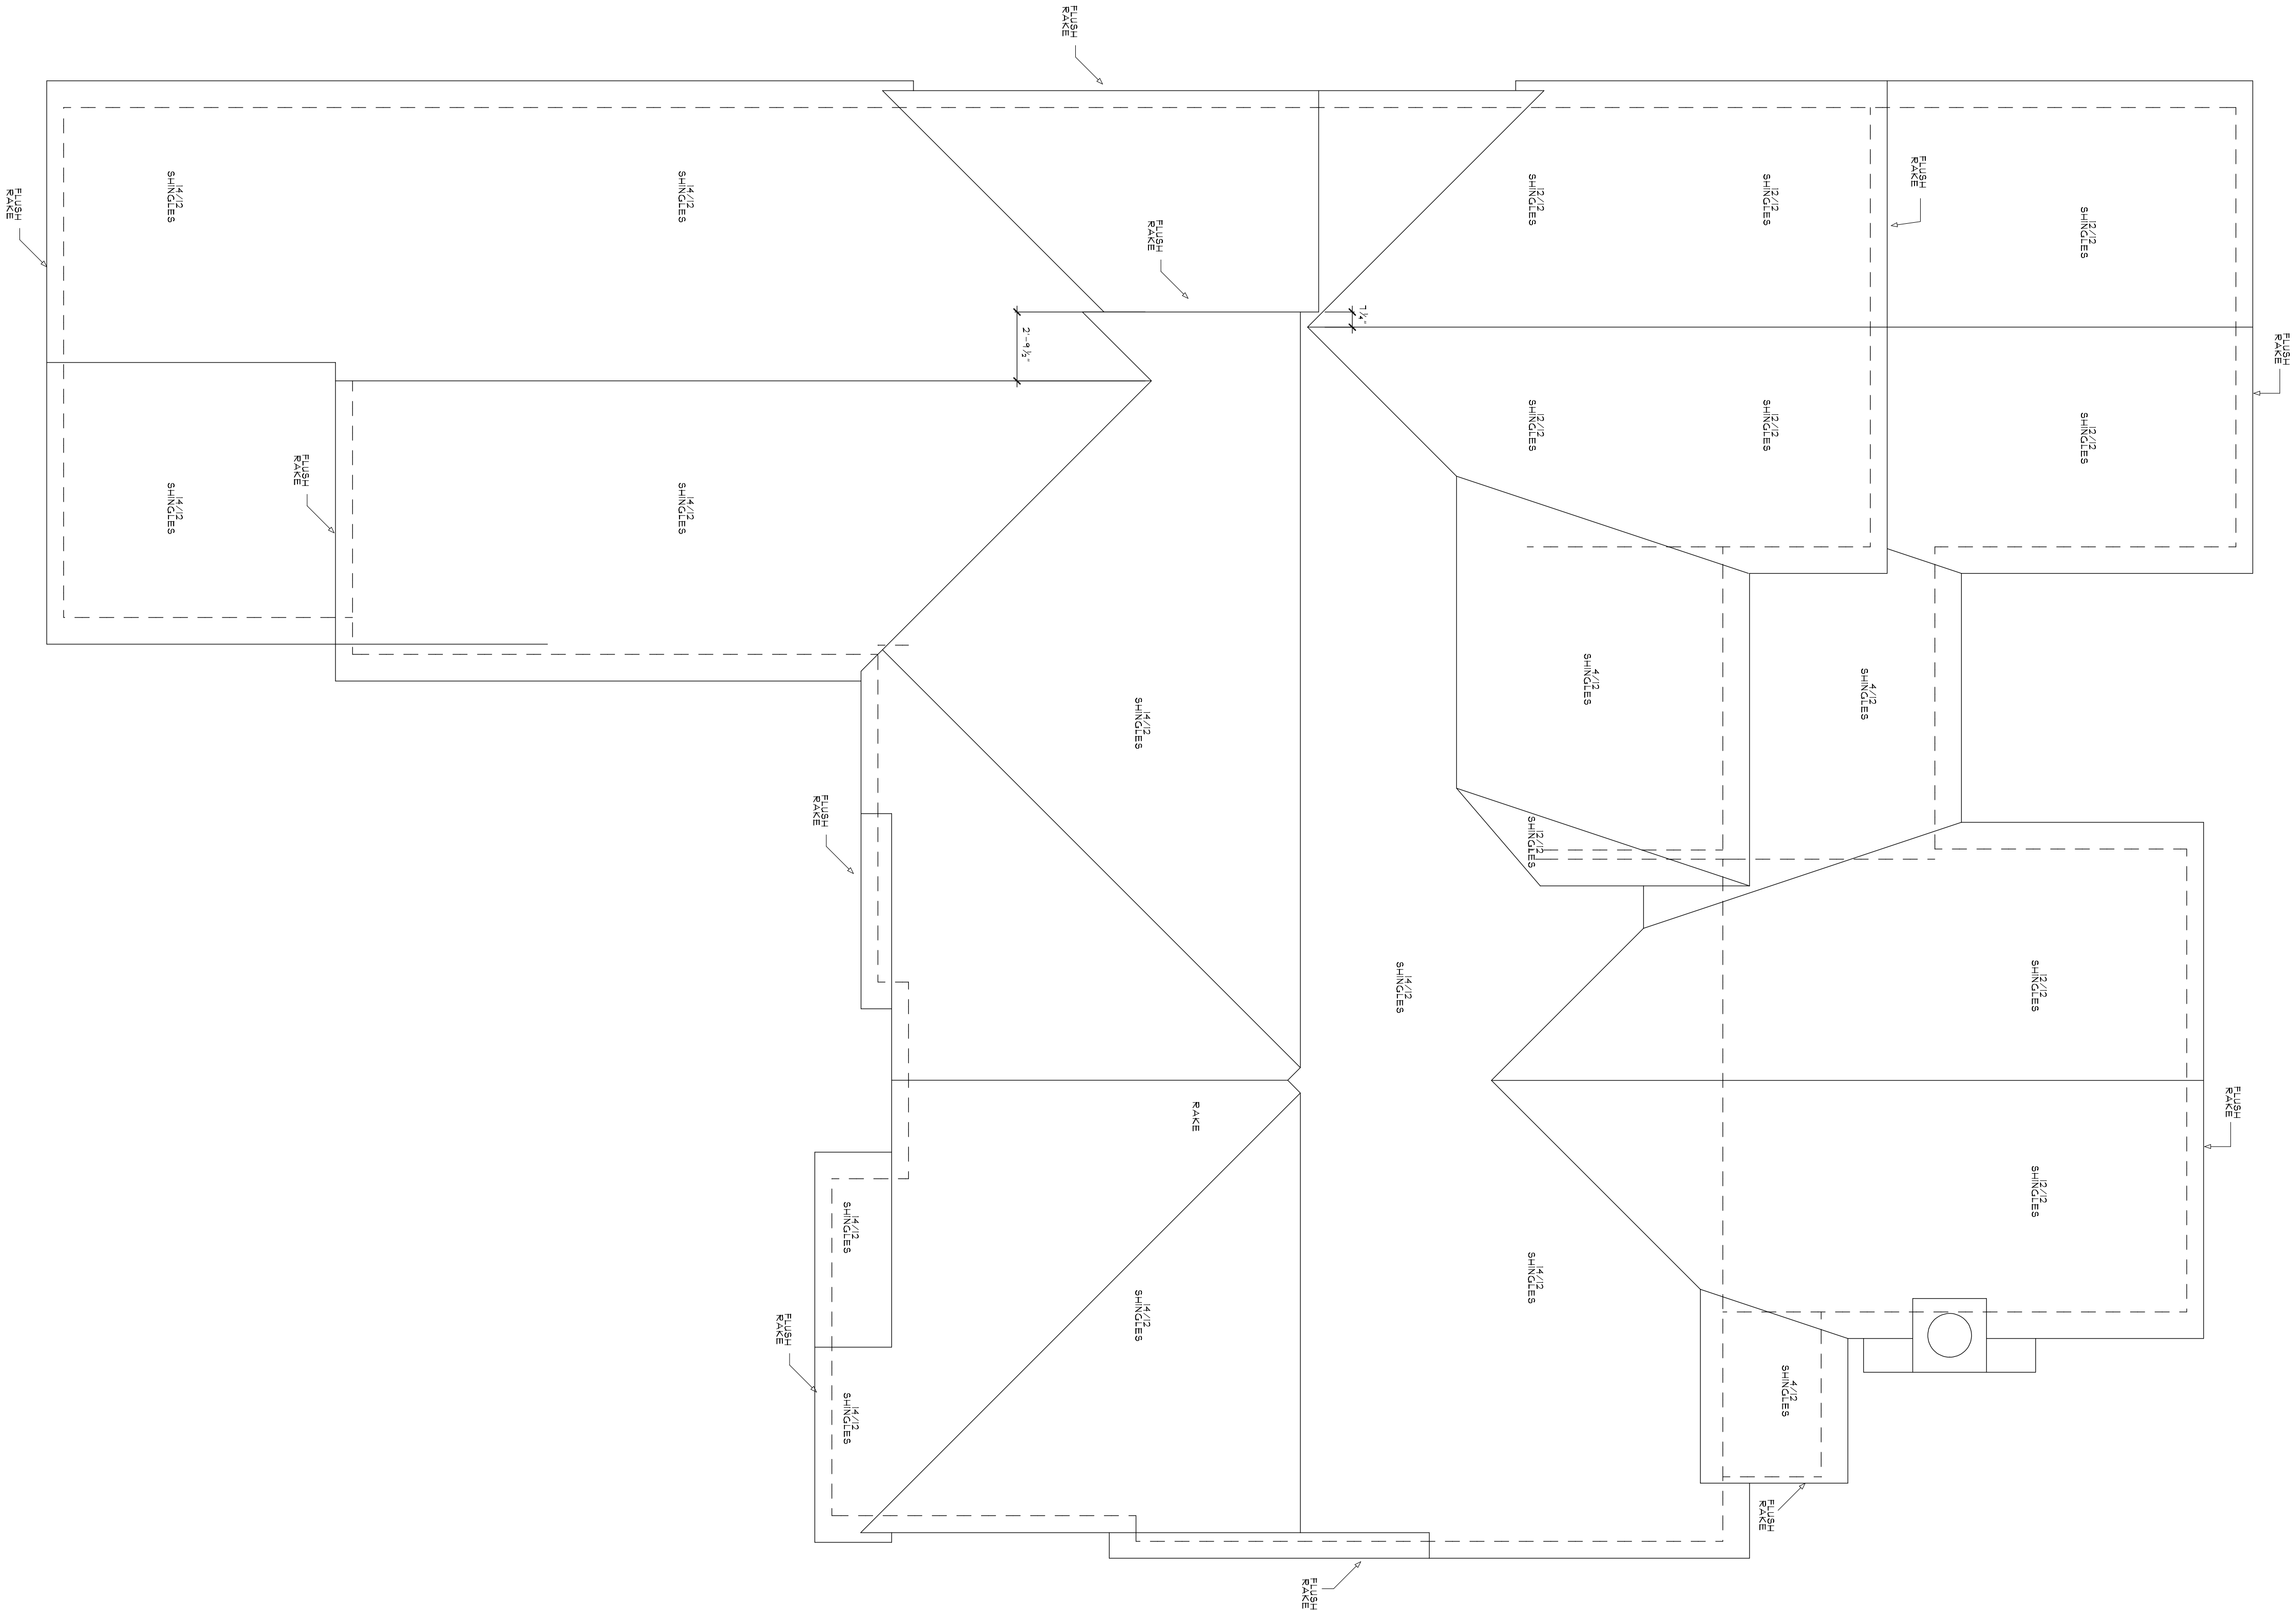

ROOF PLAN

1/4"=1'-0"

AREAS:
HTD DN 2312 SQ. FT.
HTD UP 1050 SQ. FT.
TOTAL HTD. 3362 SQ. FT.
PORCH 505 SQ. FT.
GAR & STOR. 162 SQ. FT.



SHEET
JOB NO. : B524
SCALE : AS NOTED
DATE : 10-22-2020

DRAWN :
CHECKED :


AMERICAN INSTITUTE
OF BUILDING DESIGN
®
B/D
A

CLASSIC HOME DESIGNS.
ED YENDREK AND ASSOCIATES
1133 POLO DRIVE, SUITE 105
COLLIERVILLE, TENNESSEE 38017
PHONE: 901-854-6900 FAX: 901-854-7170
WWW.CHDHOME.COM

CLASSIC HOME DESIGNS
© COPYRIGHT 2020
CHD

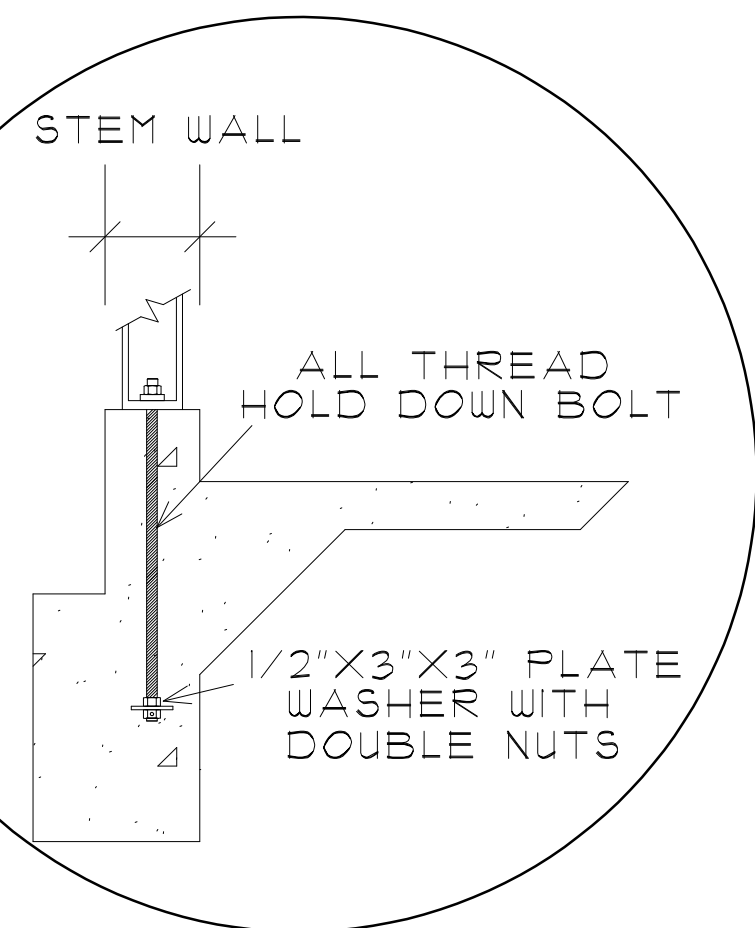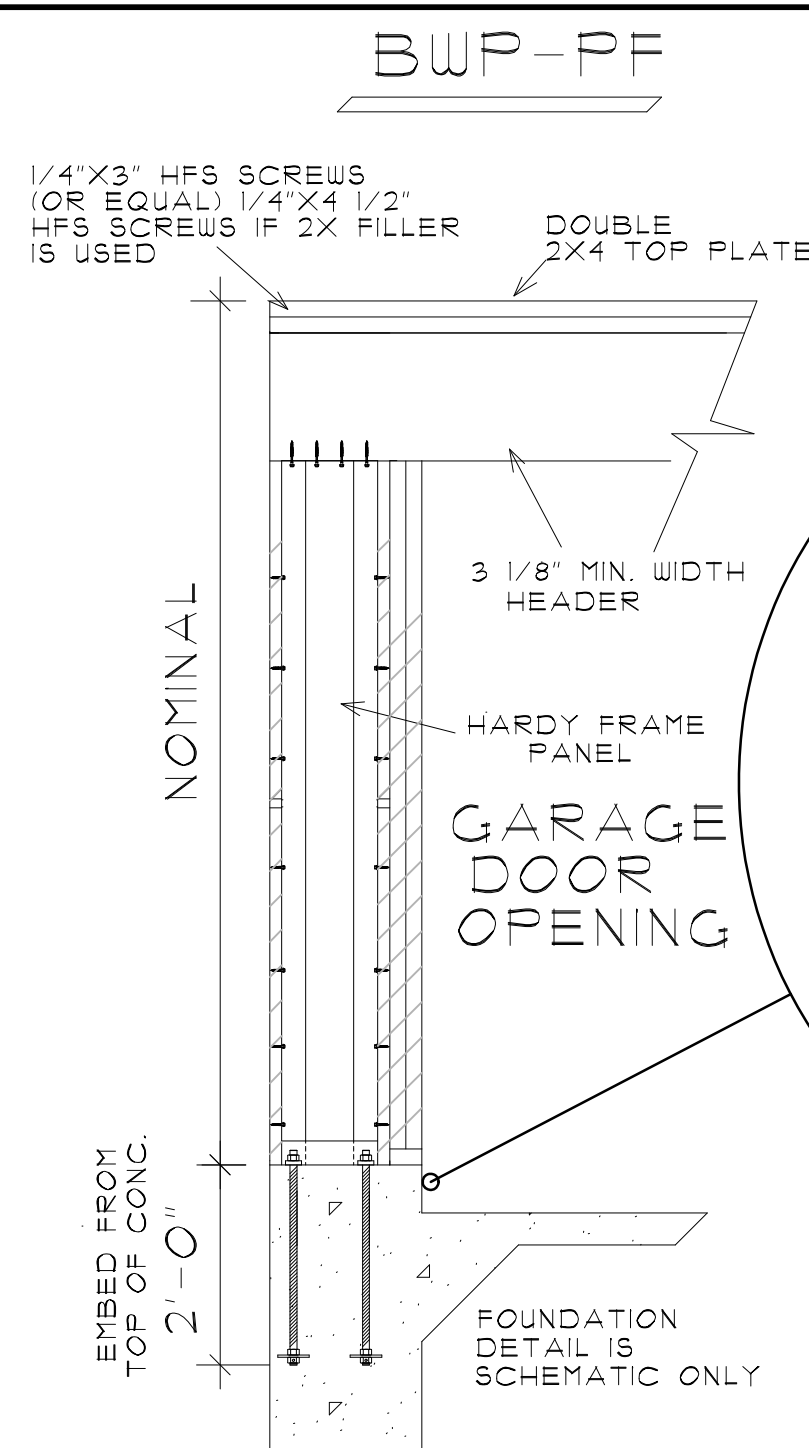


HARDY FRAME PANEL
GARAGE FRONT

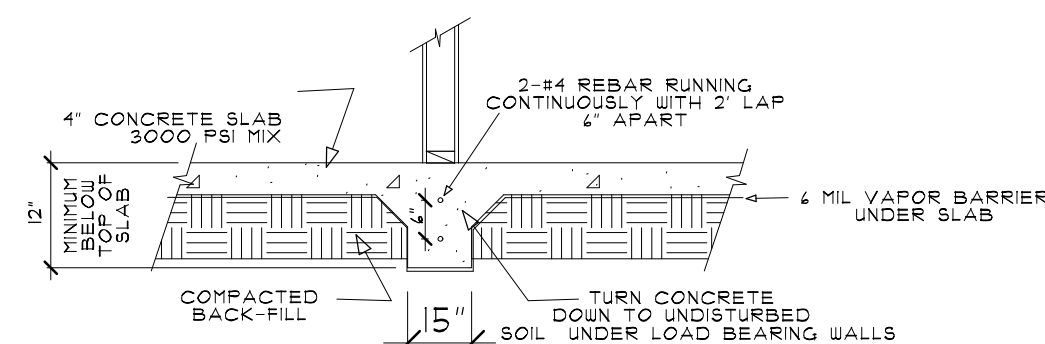


15" WIDE CONCRETE
GRADE BEAM DETAIL

DETAIL IS SCHEMATIC ONLY
CONSULT ENGINEER FOR SPECIFIC
FOOTING DETAIL UPON SITE
INSPECTION



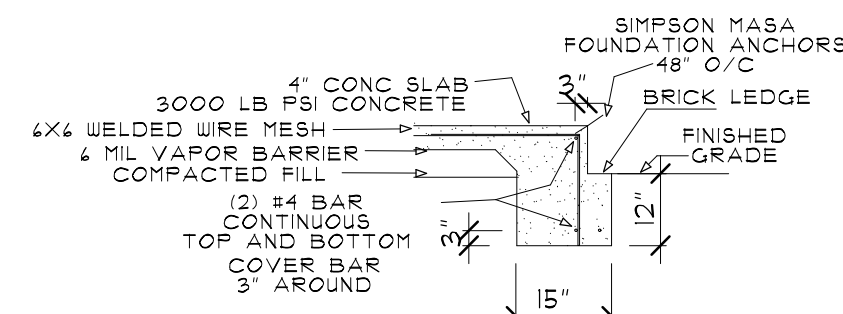


MONOLITHIC FOOTING
DETAIL

DETAIL IS SCHEMATIC ONLY
CONSULT ENGINEER FOR SPECIFIC
FOOTING DETAIL UPON SITE
INSPECTION

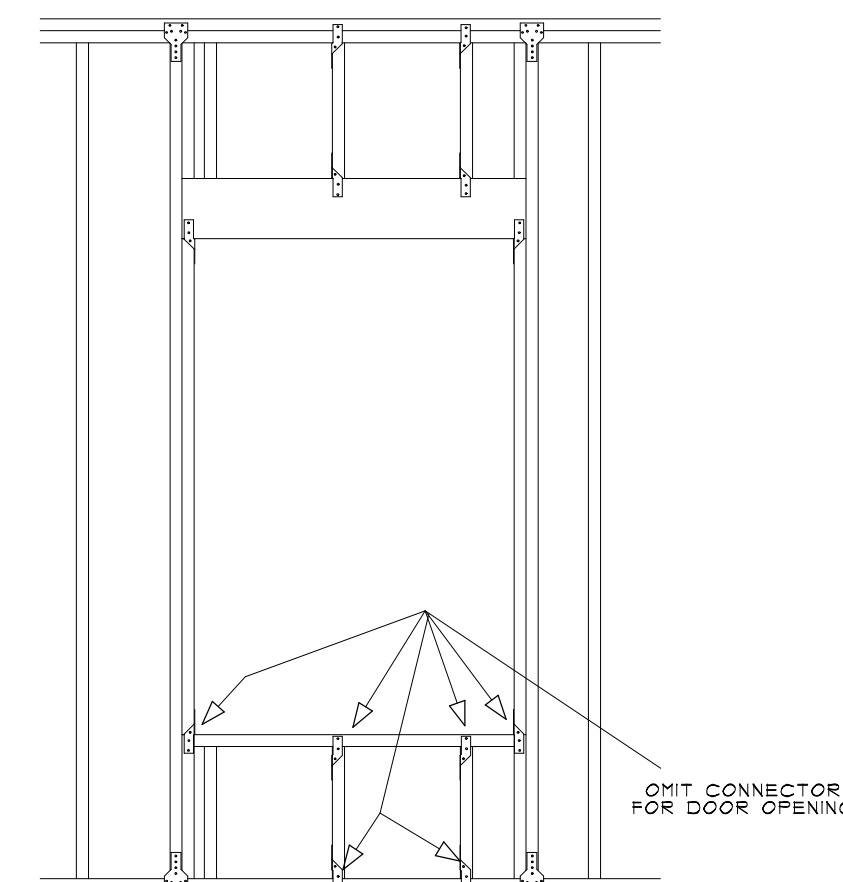

WINDOW AND DOOR
OPENING CONNECTION
DETAIL
CONSULT CONNECTION MANUFACTURER
FOR SPECIFIC CONNECTOR NAME

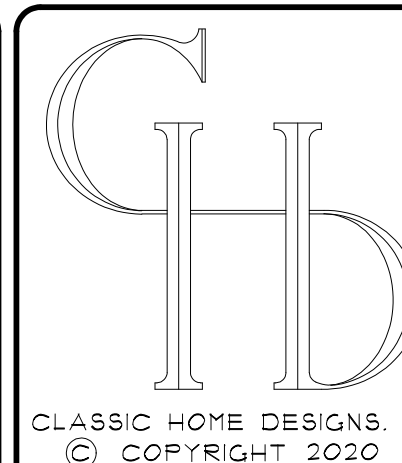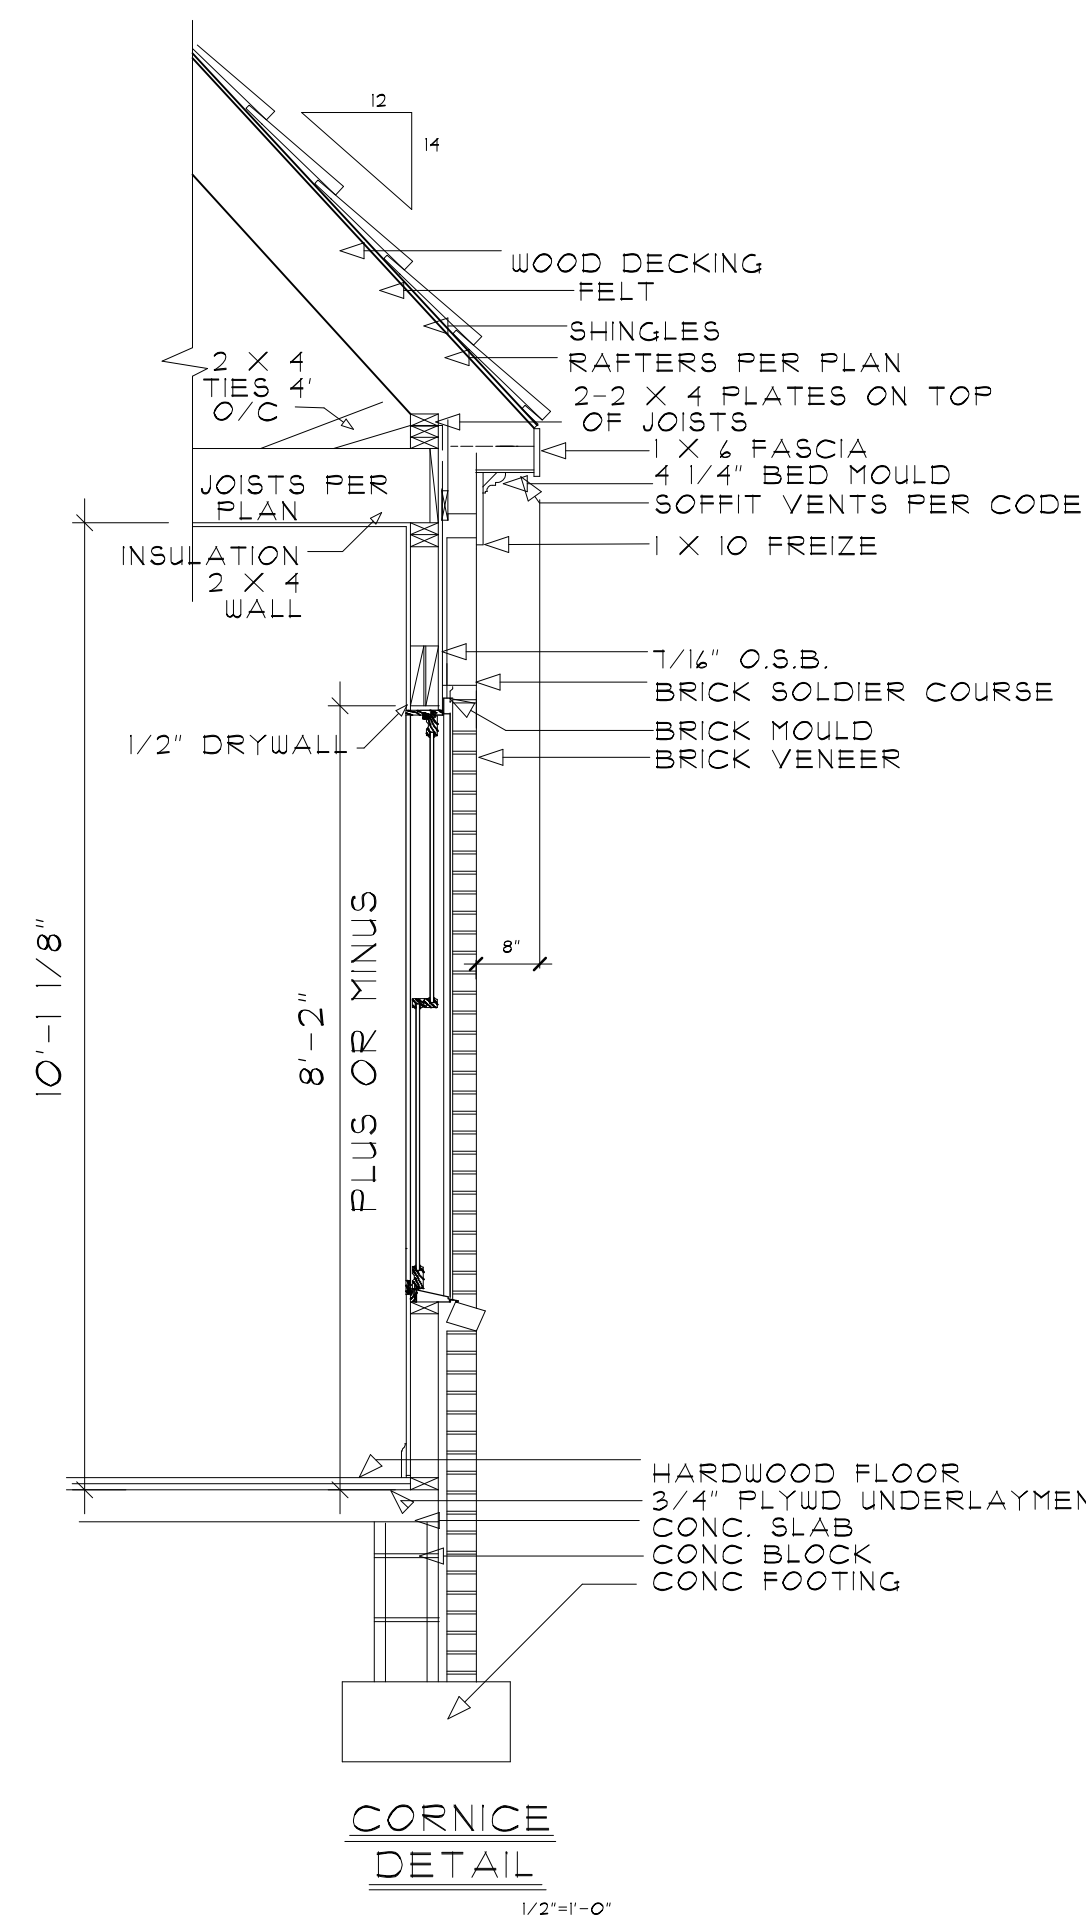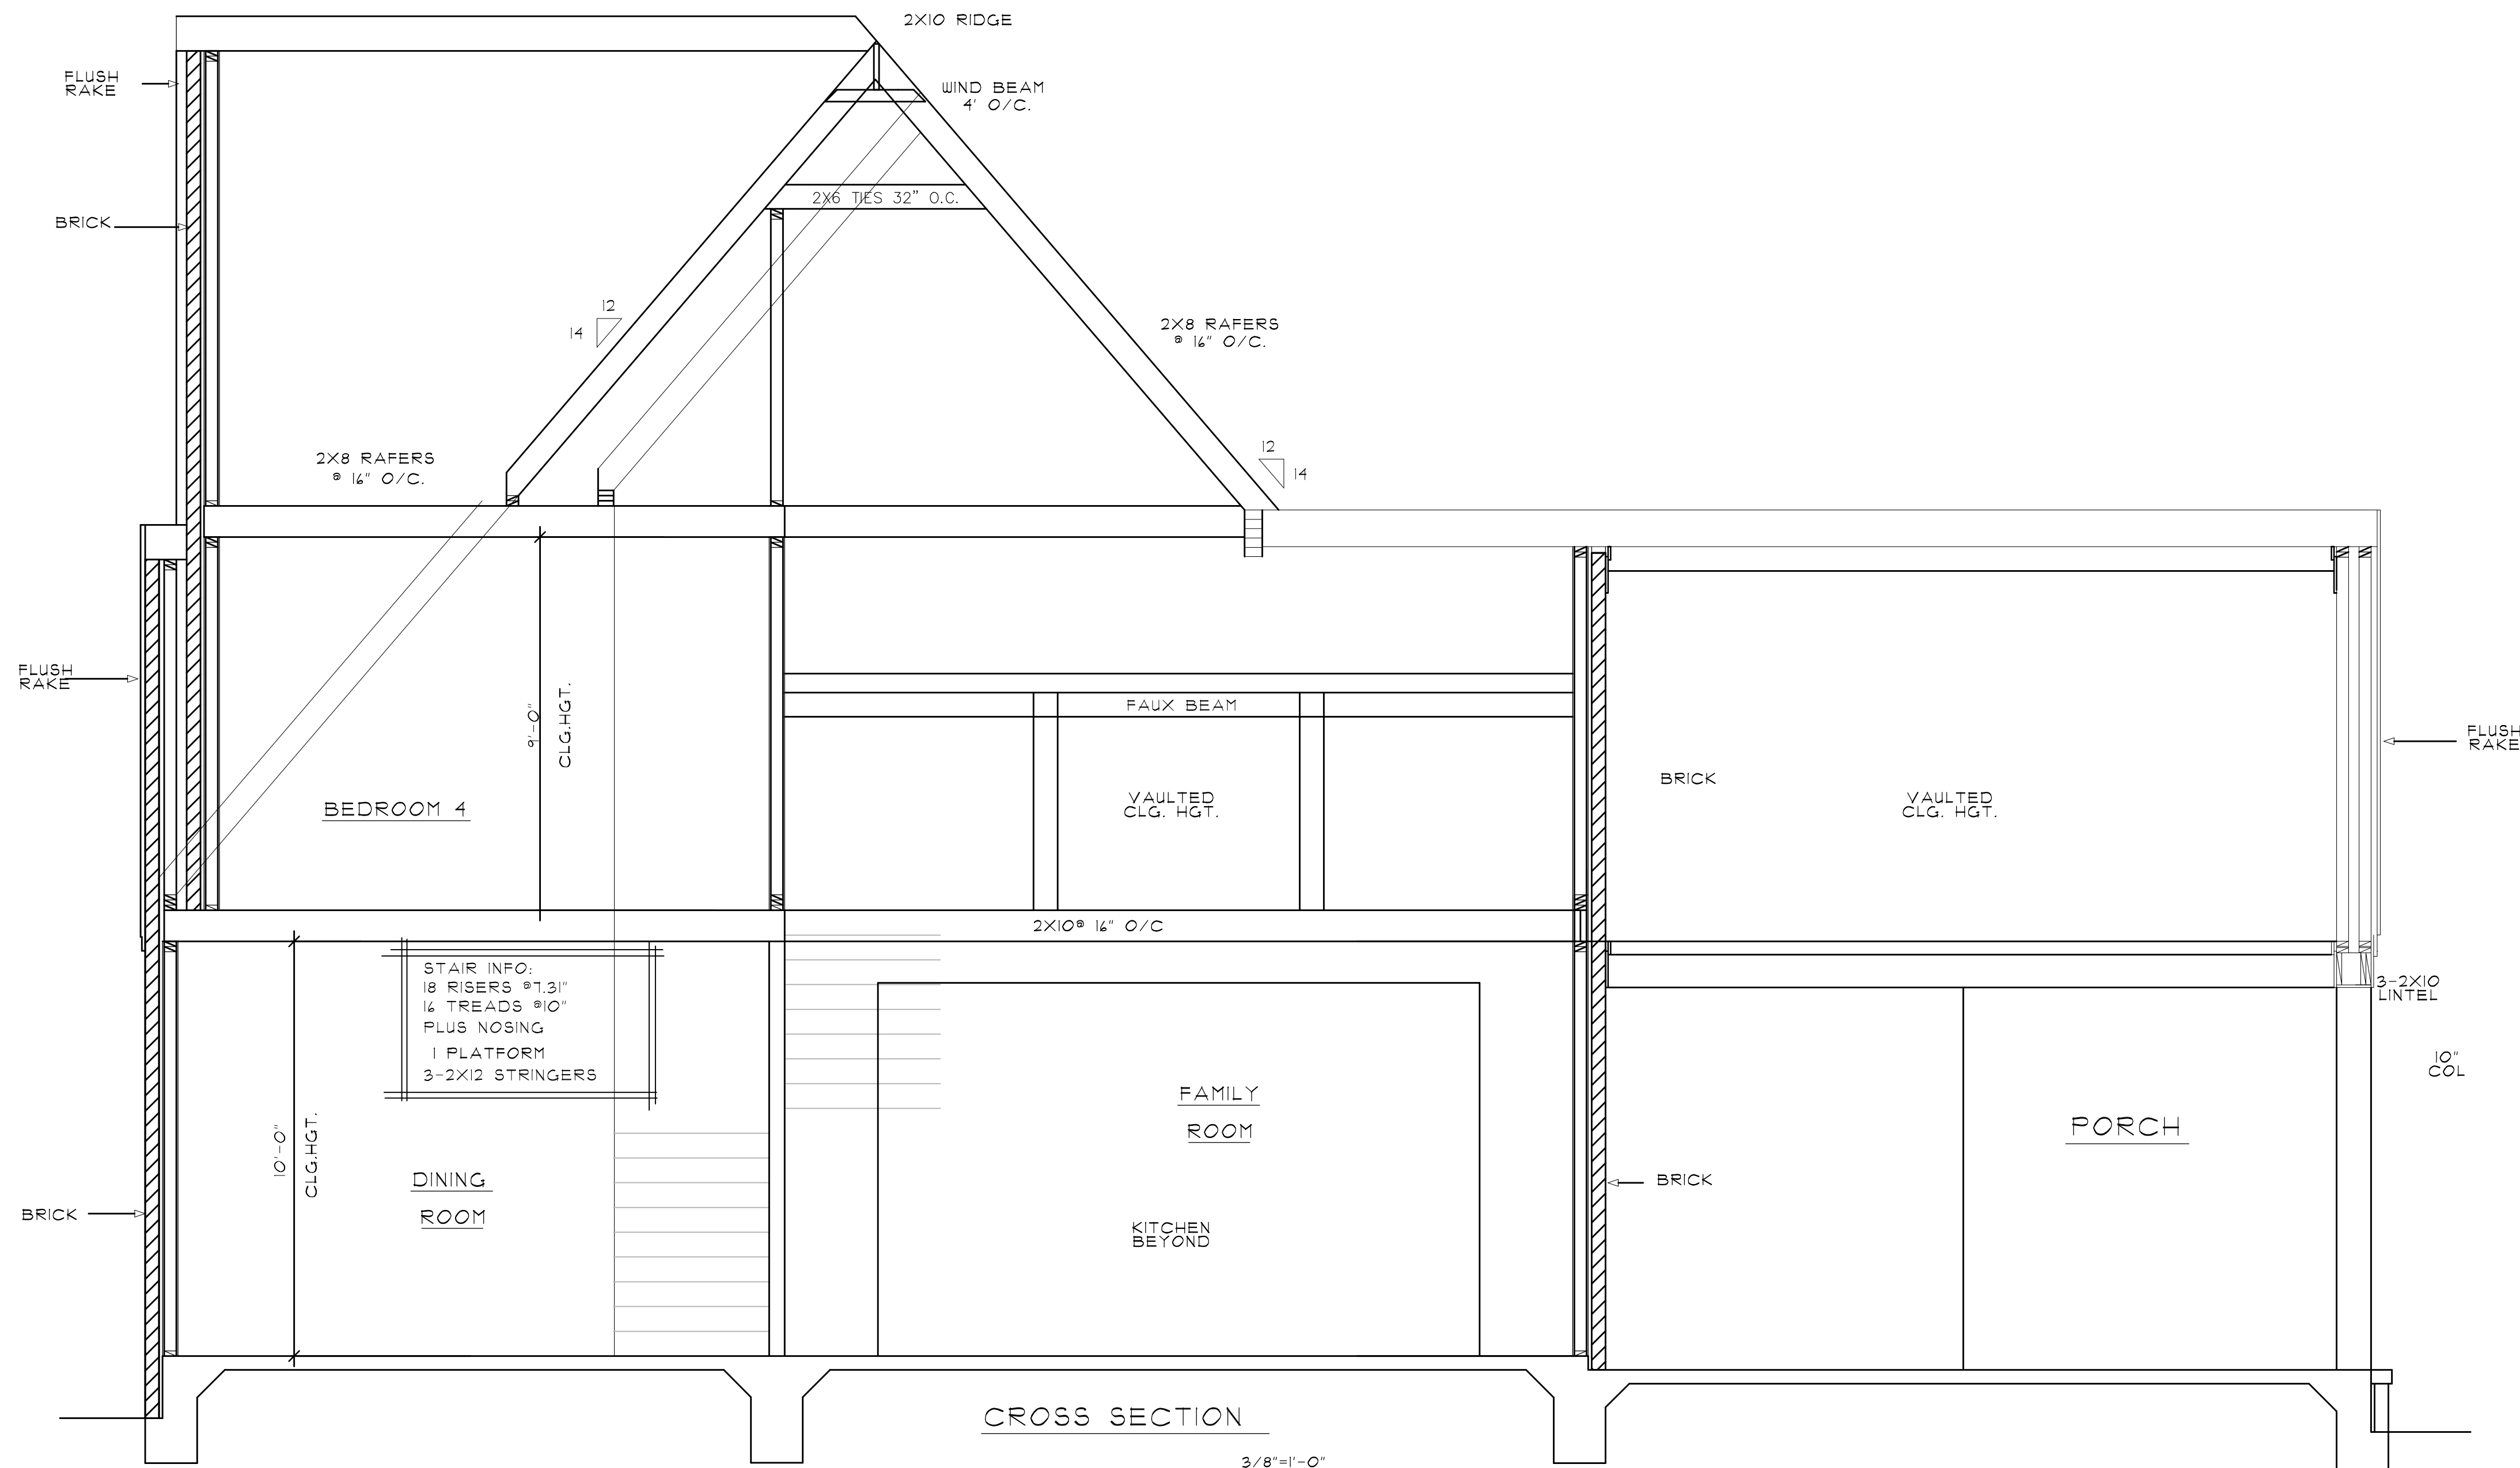

CLASSIC HOME DESIGNS.

ED YENDREK AND ASSOCIATES
1133 POLO DRIVE, SUITE 105
COLLIERVILLE, TENNESSEE 38017
PHONE: 901-854-6900 FAX: 901-854-7110
WWW.CHDHOME.COM



AREAS:	2312 SQ. FT.	1050 SQ. FT.
HTD DN		
HTD UP		
TOTAL HTD.	3362 SQ. FT.	
HTD. BRICK	3488 SQ. FT.	
PORCH	505 SQ. FT.	
GAR & STOR.	162 SQ. FT.	

DRAWN :	CHECKED :
DATE :	10-22-2020
SCALE :	AS NOTED
JOB NO. :	B524
SHEET	